



County of El Paso Purchasing Department
800 E. Overland Room 300
El Paso, Texas 79901
(915) 546-2048 / Fax: (915) 546-8180

ADDENDUM 6

To: All Interested Proposers


From: Linda Mena, Inventory Bid Technician

Date: May 14, 2010

Subject: BID # 10-024, Construction Improvements for the Juvenile Justice Center

Please Note:

The following pages are plumbing sheets that are mentioned in the Addendum #5

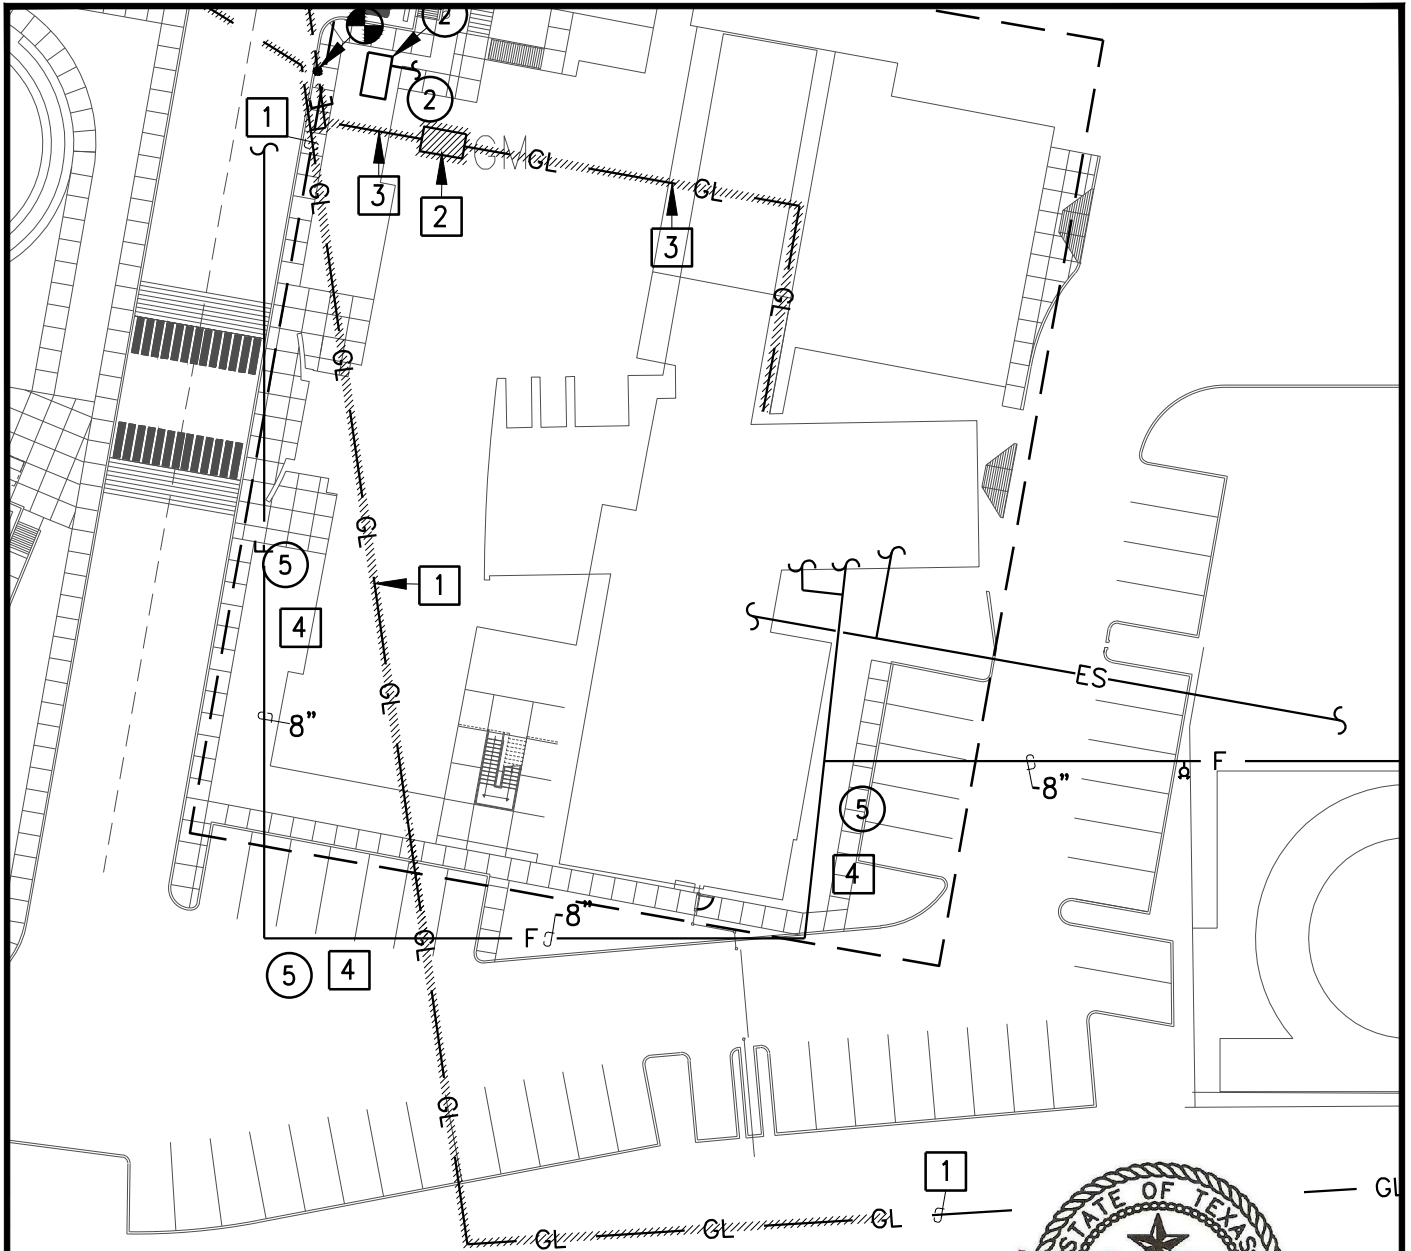

PARTIAL PLUMBING SITE PLAN



1
P-102

SCALE: 1" = 40'-0"



THE SEAL APPEARING ON THIS DOCUMENT WAS AUTHORIZED BY MELVIN G. GLASS, P.E. #64955 OF EMC ENGINEERS (TEXAS FIRM REG. #F2491) ON MAY 06, 2010. ALTERATION OF A SEALED DOCUMENT WITHOUT PROPER NOTIFICATION TO THE RESPONSIBLE ENGINEER IS AN OFFENSE UNDER THE TEXAS ENGINEERING PRACTICE ACT.



EMC ENGINEERS
2211 E. MISSOURI AVE. SUITE W-107
EL PASO, TEXAS. 79903
PH: 915-781-2030
FAX: 915-781-2055


Purpose:	ADD. #3	Project:	COUNTY YOUTH AND JPD
Designed By:	M.G.G	Location:	EL PASO, TEXAS
Drawn By:	A.N	EMC Job Number:	EMC-0806044
Checked By:	MG.G	Date:	05/06/10
Scale:	AS SHOWN	Sheet: P-102	1 of 2

PLUMBING REMODEL NOTES:

- ① RELOCATED INTERMEDIATE PRESSURE GAS MAIN TO BE REROUTED TO RELOCATED GAS METER LOCATION. COORDINATE RELOCATION WITH TEXAS GAS UTILITY.
- ② RELOCATED GAS METER ASSEMBLY AND ASSOCIATED GAS MAIN ENTRY PIPING TO BE RELOCATED AS INDICATED TO MISS THE NEW BUILDING ADDITION. COORDINATE WITH TEXAS GAS UTILITY. REFER TO SHEET P-103 FOR GAS PIPING TO BUILDING.
- ③ EPWU TO SIZE NEW WATER LINE FROM TAP TO METER FOR NEW IRRIGATION BACK FLOW.
- ④ NEW 1-1/2" IRRIGATION BACK FLOW PER CODE REQUIREMENTS. PLUMBING CONTRACTOR TO INSTALL AND COORDINATE LOCATION WITH LANDSCAPE CONTRACTOR. INSTALL NEW BACKFLOW PER SCHEMATIC 19/P-110.
- ⑤ EXISTING FIRE MAIN COORDINATE LOCATION WITH NEW BUILDING FOOT PRINT RELOCATE AS REQUIRED TO MISS BUILDING ADDITION.

PLUMBING DEMOLITION NOTES:

- ① EXISTING INTERMEDIATE PRESSURE GAS MAIN TO BE ABANDON IN PLACE ABANDONED OR REMOVE EXISTING PIPING AS REQUIRED. COORDINATE RELOCATION AND SIZE WITH TEXAS GAS UTILITY.
- ② EXISTING GAS METER ASSEMBLY AND ASSOCIATED GAS MAIN ENTRY PIPING TO BE RELOCATED TO MISS THE NEW BUILDING ADDITION. COORDINATE WITH TEXAS GAS UTILITY.
- ③ ABANDONED EXISTING GAS LINE BELOW GRADE. CONTRACTOR TO VERIFY AND COORDINATE ALL GAS LINES SERVING EXISTING BUILDING WILL BE MOVED AND RECONNECTED TO NEW GAS METER LOCATION. REFER TO 1/P-102 FOR FURTHER INFORMATION OF EXISTING GAS LINE.
- ④ EXISTING FIRE MAIN COORDINATE LOCATION WITH NEW BUILDING FOOT PRINT RELOCATE AS REQUIRED TO MISS BUILDING ADDITION.

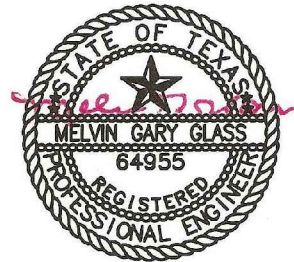

THE SEAL APPEARING ON THIS DOCUMENT WAS AUTHORIZED BY MELVIN G. GLASS, P.E. #64955 OF EMC ENGINEERS (TEXAS FIRM REG. #F2491) ON MAY 06, 2010. ALTERATION OF A SEALED DOCUMENT WITHOUT PROPER NOTIFICATION TO THE RESPONSIBLE ENGINEER IS AN OFFENSE UNDER THE TEXAS ENGINEERING PRACTICE ACT.



EMC ENGINEERS
2211 E. MISSOURI AVE. SUITE W-107
EL PASO, TEXAS 79903
PH: 915-781-2030
FAX: 915-781-2055

Purpose:	ADD. #3	Project:	COUNTY YOUTH AND JPD
Designed By:	M.G.G	Location:	EL PASO, TEXAS
Drawn By:	A.N	EMC Job Number:	EMC-0806044
Checked By:	MG.G	Date:	05/06/10
Scale:	AS SHOWN	Sheet: P-102	2 of 2