

REMODELING OF THE ASCARATE ANNEX FOR THE EL PASO COUNTY
 301 MANNY MARTINEZ DR., EL PASO, TEXAS 79905


ISSUED FOR CONSTRUCTION

NO.	DATE	REVISION:
1	04/03/2014	ADA REVISIONS
2	04/21/2014	REVISIONS
DATE: FEBRUARY 17, 2014		



SHEET:
A2.2
 REVISED 1ST FLOOR PLAN

2013-32-REMODELING OF THE ASCARATE ANNEX FOR THE EL PASO COUNTY- 100% CONSTRUCTION DOCUMENTS FEBRUARY 17, 2014



ROOM FINISH SCHEDULE

NO.	ROOM NAME	FLOOR	BASE	WALLS				CEILING	REMARKS
				SOUTH	WEST	NORTH	EAST		
101	LOBBY	12"x12" VCT	CERAMIC	PAIN	PAIN	PAIN	PAIN	2'x4' ACOUSTICAL	
102	HOTEL AND BEVERAGE	12"x12" VCT	4" COVED, VINYL	PAIN	PAIN	PAIN	PAIN	2'x4' ACOUSTICAL	
103	VTC WORK STATIONS	12"x12" VCT	4" COVED, VINYL	PAIN	PAIN	PAIN	PAIN	2'x4' ACOUSTICAL	
104	REGISTRATION DIRECTOR	CARPET	4" COVED, VINYL	PAIN	PAIN	PAIN	PAIN	2'x4' ACOUSTICAL	
105	ASST. MANAGER	CARPET	4" COVED, VINYL	PAIN	PAIN	PAIN	PAIN	2'x4' ACOUSTICAL	
106	OFFICE MANAGER	CARPET	4" COVED, VINYL	PAIN	PAIN	PAIN	PAIN	2'x4' ACOUSTICAL	
107	INVENTORY CLERKS	CARPET	4" COVED, VINYL	PAIN	PAIN	PAIN	PAIN	2'x4' ACOUSTICAL	
108	SECURE STORAGE	12"x12" VCT	4" COVED, VINYL	PAIN	PAIN	PAIN	PAIN	2'x4' ACOUSTICAL	
109	RECEIVING	12"x12" VCT	4" COVED, VINYL	PAIN	PAIN	PAIN	PAIN	2'x4' ACOUSTICAL	
110	VAULT	12"x12" VCT	CERAMIC	PAIN	PAIN	PAIN	PAIN	2'x4' ACOUSTICAL	
111	VTC WORK STATIONS	12"x12" VCT	4" COVED, VINYL	PAIN	PAIN	PAIN	PAIN	2'x4' ACOUSTICAL	
112	CORRIDOR	12"x12" VCT	4" COVED, VINYL	PAIN	PAIN	PAIN	PAIN	2'x4' ACOUSTICAL	
113	QUEING	12"x12" VCT	4" COVED, VINYL	PAIN	PAIN	PAIN	PAIN	2'x4' ACOUSTICAL	
114	SWITCH BOARD	CARPET	4" COVED, VINYL	PAIN	PAIN	PAIN	PAIN	2'x4' ACOUSTICAL	
115	WOMEN H/C ACCESSIBLE RR	12"x12" VCT	TILE	TILE	TILE	TILE	TILE	2'x4' ACOUSTICAL	5'-4" HEIGHT TILE
116	MEN H/C ACCESSIBLE RR	12"x12" VCT	TILE	TILE	TILE	TILE	TILE	2'x4' ACOUSTICAL	5'-4" HEIGHT TILE
117	WAITING	12"x12" VCT	4" COVED, VINYL	PAIN	PAIN	PAIN	PAIN	2'x4' ACOUSTICAL	
118	VICTOR FLORES	CARPET	4" COVED, VINYL	PAIN	PAIN	PAIN	PAIN	2'x4' ACOUSTICAL	
119	FRANK ORTIS	CARPET	CERAMIC	PAIN	PAIN	PAIN	PAIN	2'x4' ACOUSTICAL	
120	SECRETARIAL AREA	CARPET	4" COVED, VINYL	PAIN	PAIN	PAIN	PAIN	2'x4' ACOUSTICAL	
121	LETTY	CARPET	4" COVED, VINYL	PAIN	PAIN	PAIN	PAIN	2'x4' ACOUSTICAL	
122	ANGELA	CARPET	4" COVED, VINYL	PAIN	PAIN	PAIN	PAIN	2'x4' ACOUSTICAL	
123	ACCOUNTING STAFF	12"x12" VCT	4" COVED, VINYL	PAIN	PAIN	PAIN	PAIN	2'x4' ACOUSTICAL	
124	IT CLOSET	12"x12" VCT	4" COVED, VINYL	PAIN	PAIN	PAIN	PAIN	2'x4' ACOUSTICAL	
125	OFFICE	CARPET	4" COVED, VINYL	PAIN	PAIN	PAIN	PAIN	2'x4' ACOUSTICAL	
126	OFFICE	CARPET	4" COVED, VINYL	PAIN	PAIN	PAIN	PAIN	2'x4' ACOUSTICAL	
127	OFFICE	CARPET	4" COVED, VINYL	PAIN	PAIN	PAIN	PAIN	2'x4' ACOUSTICAL	
128	OFFICE	CARPET	CERAMIC	PAIN	PAIN	PAIN	PAIN	2'x4' ACOUSTICAL	
129	OFFICE	CARPET	4" COVED, VINYL	PAIN	PAIN	PAIN	PAIN	2'x4' ACOUSTICAL	
130	ENFORCEMENT AREA	12"x12" VCT	4" COVED, VINYL	PAIN	PAIN	PAIN	PAIN	2'x4' ACOUSTICAL	
131	EXISTING CORRIDOR	12"x12" VCT	4" COVED, VINYL	PAIN	PAIN	PAIN	PAIN	2'x4' ACOUSTICAL	
132	ENFORCEMENT	12"x12" VCT	4" COVED, VINYL	PAIN	PAIN	PAIN	PAIN	2'x4' ACOUSTICAL	
133	OFFICE	CARPET	4" COVED, VINYL	PAIN	PAIN	PAIN	PAIN	2'x4' ACOUSTICAL	
134	OFFICE	CARPET	4" COVED, VINYL	PAIN	PAIN	PAIN	PAIN	2'x4' ACOUSTICAL	
135	FILE ROOM	12"x12" VCT	4" COVED, VINYL	PAIN	PAIN	PAIN	PAIN	2'x4' ACOUSTICAL	
136	ELECTRICAL ROOM	12"x12" VCT	4" COVED, VINYL	PAIN	PAIN	PAIN	PAIN	2'x4' ACOUSTICAL	
137	SUPPLY ROOM	12"x12" VCT	CERAMIC	PAIN	PAIN	PAIN	PAIN	2'x4' ACOUSTICAL	
138	BREAKROOM	12"x12" VCT	4" COVED, VINYL	PAIN	PAIN	PAIN	PAIN	2'x4' ACOUSTICAL	
139	VIT CLERK	CARPET	4" COVED, VINYL	PAIN	PAIN	PAIN	PAIN	2'x4' ACOUSTICAL	
140	JANITOR	12"x12" VCT	4" COVED, VINYL	PAIN	PAIN	PAIN	PAIN	2'x4' ACOUSTICAL	
141	WOMEN'S RESTROOM	12"x12" VCT	TILE	TILE	TILE	TILE	TILE	2'x4' ACOUSTICAL	5'-4" HEIGHT TILE
142	MEN'S RESTROOM	12"x12" VCT	TILE	TILE	TILE	TILE	TILE	2'x4' ACOUSTICAL	5'-4" HEIGHT TILE
143	EXISTING CORRIDOR	12"x12" VCT	4" COVED, VINYL	PAIN	PAIN	PAIN	PAIN	2'x4' ACOUSTICAL	
144	EXISTING STAIRS 1	12"x12" VCT	4" COVED, VINYL	PAIN	PAIN	PAIN	PAIN	2'x4' ACOUSTICAL	
145	EXISTING STAIRS 2	12"x12" VCT	4" COVED, VINYL	PAIN	PAIN	PAIN	PAIN	2'x4' ACOUSTICAL	
146	STORAGE	12"x12" VCT	4" COVED, VINYL	PAIN	PAIN	PAIN	PAIN	2'x4' ACOUSTICAL	
147	ELEVATOR MECHANICAL ROOM	12"x12" VCT	4" COVED, VINYL	PAIN	PAIN	PAIN	PAIN	2'x4' ACOUSTICAL	



- REMARKS:
- VCT FLOORING ACCENT COLOR FROM MANUFACTURER'S STANDARD COLORS, NOT TO EXCEED 10% OF TOTAL FLOOR INSTALLED, RANDOM PATTERN T.B.D. BY ARCHITECT, CORRIDOR ONLY.
 - PRE-FORMED OUTSIDE CORNER GUARDS. PROVIDE AND INSTALL ABOVE CERAMIC WAINSCOT TO UNDERSIDE OF CEILING.
 - PROVIDE & INSTALL FULL HEIGHT PRE-FORMED OUTSIDE CORNER GUARDS.
 - CERAMIC WAINSCOT TO 54" A.F.F. INCLUDE BULL NOSE TRIM FOR TOP EDGE AND COVED BASE. PAINT AND TEXTURE ABOVE WAINSCOT TO 6" ABOVE CEILING HEIGHT.
 - WALL TEXTURE FOR ALL INTERIOR WALLS SHALL BE "ORANGE PEEL", CONTRACTOR TO PROVIDE A SAMPLE FOR APPROVAL BY THE ARCHITECT BEFORE EXECUTING THE WORK.

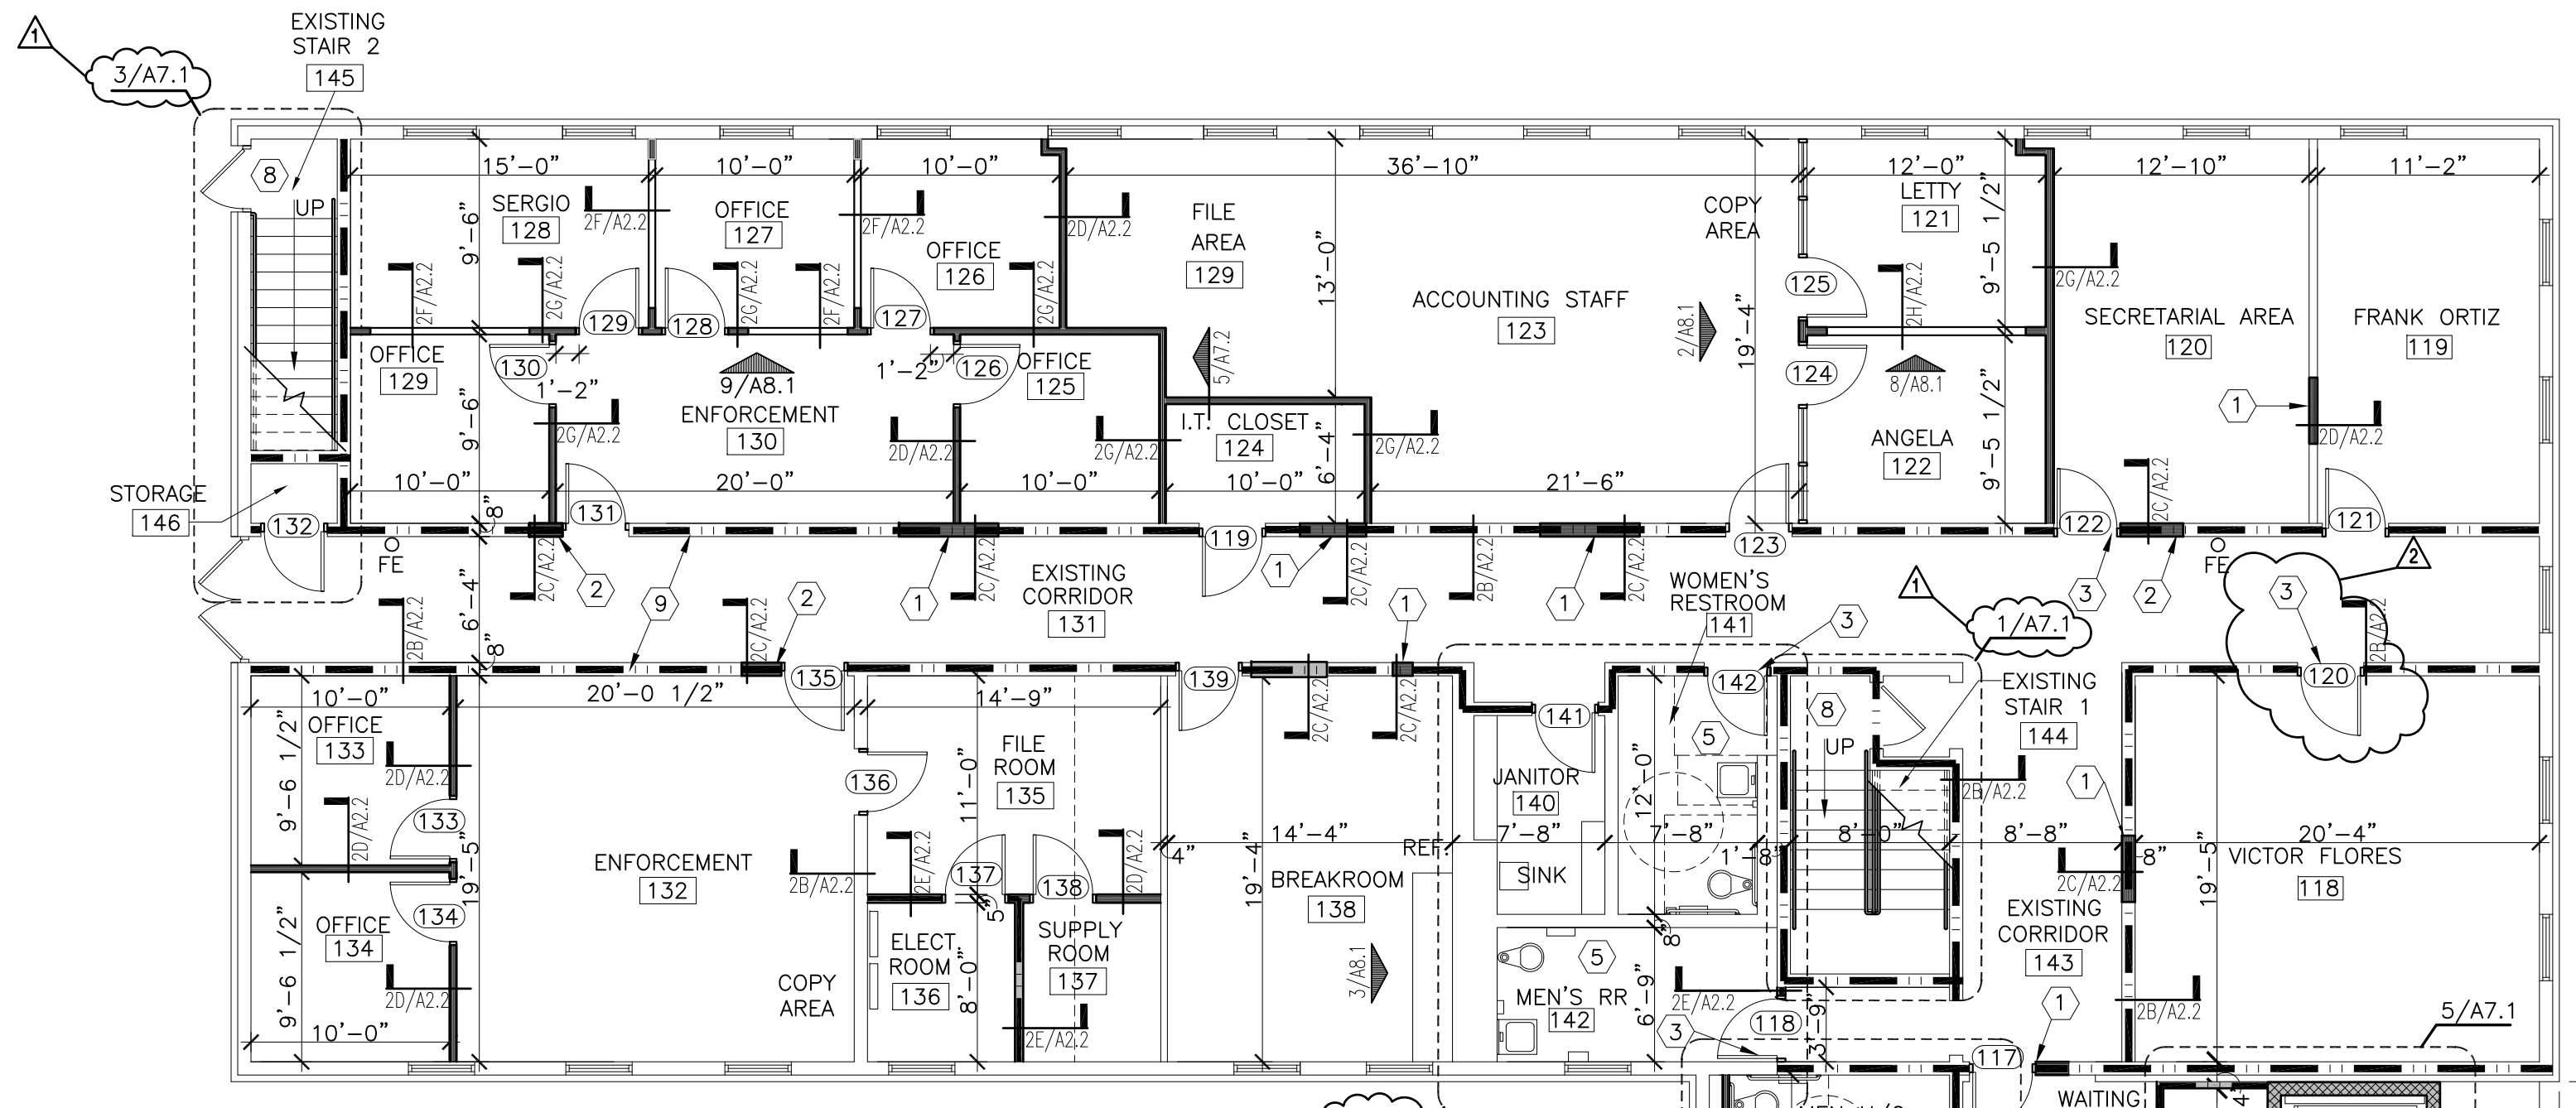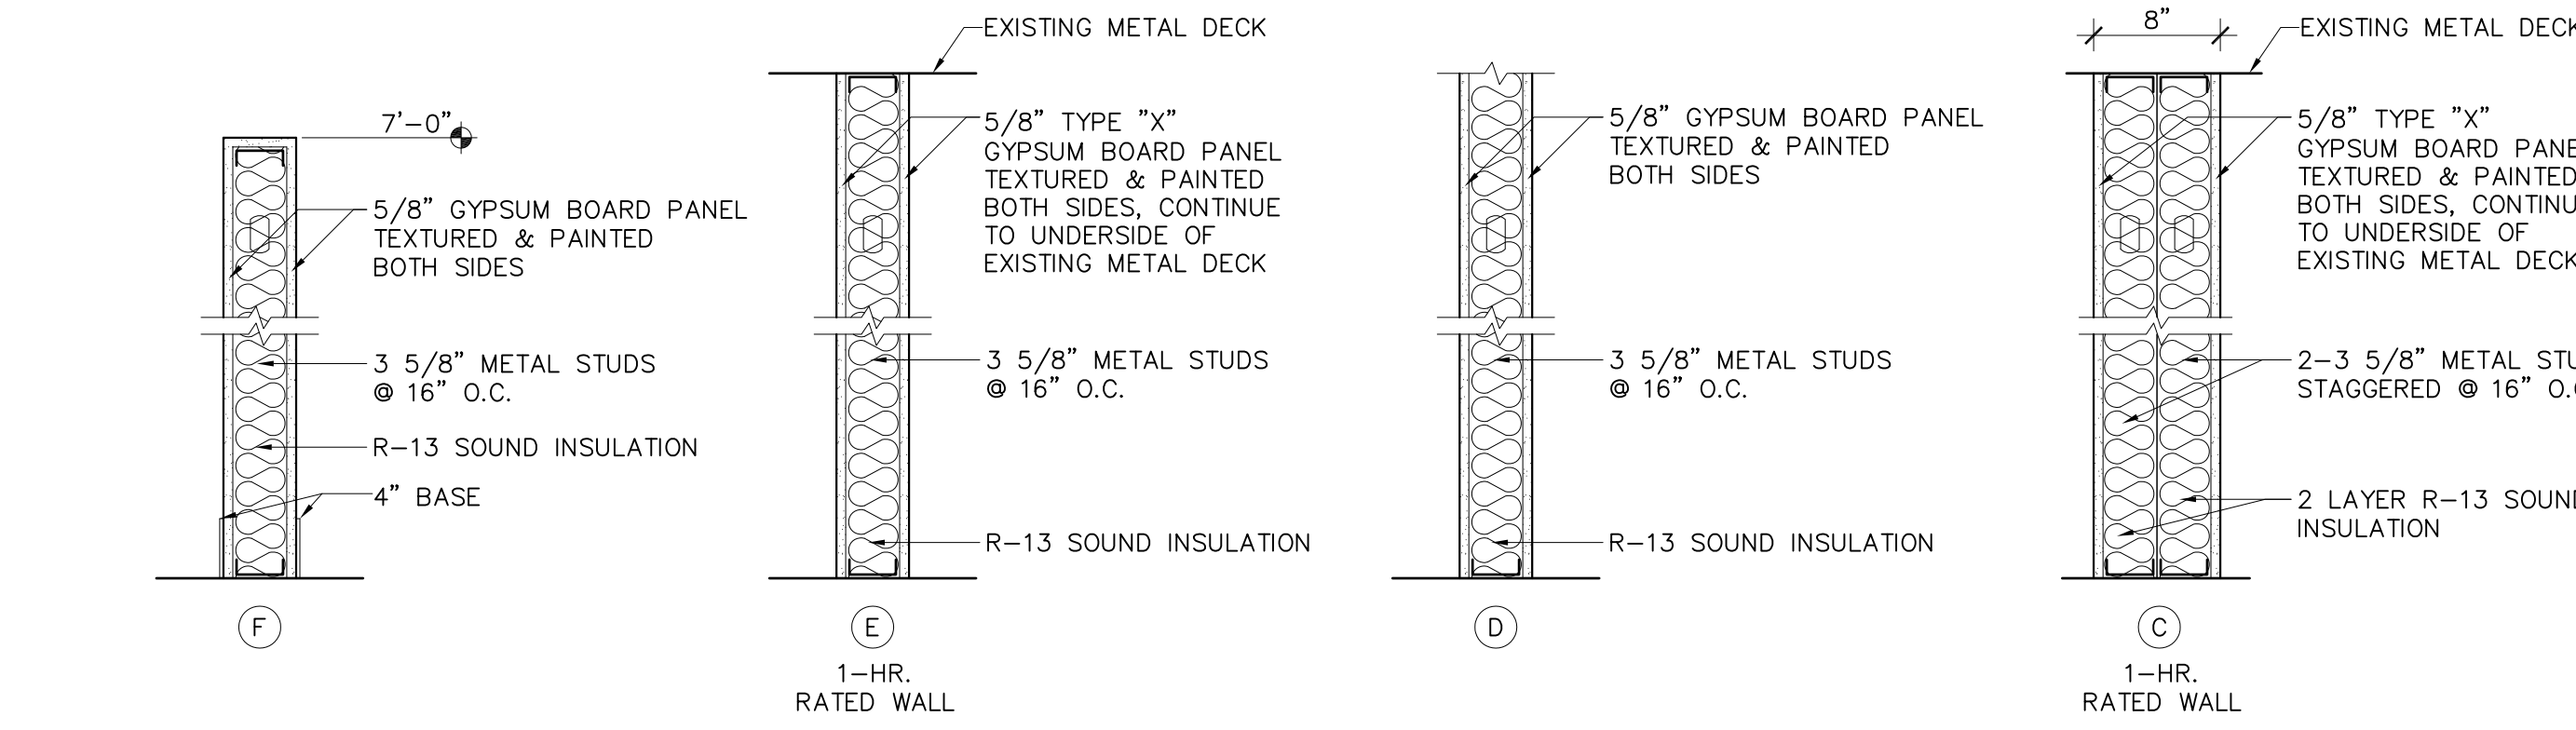

- REMODELING NOTES**
- FILL EXISTING DOOR OPENING WITH METAL STUDS AND GYP FLUSH WITH EXISTING ADJACENT SURFACES AND FINISHES. INSURE PATCH IS 1 HR. RATED
 - MODIFY EXISTING DOOR OPEN WITH METAL STUDS AND GYP BD. TO ACCOMMODATE NEW SCHEDULED DOOR. INSURE PATCH IS 1 HR. RATED
 - ENLARGE EXISTING DOOR OPENING TO ACCOMMODATE NEW SCHEDULED DOOR PATCH AND REPAIR REMAINING SURFACES TO MATCH EXISTING ADJACENT SURFACES
 - FILL EXISTING OPENING WITH METAL STUDS AND GYP FLUSH WITH EXISTING ADJACENT SURFACES AND FINISHES. INSURE PATCH IS 1 HR. RATED
 - INSTALL ALL NEW FIXTURES AND ACCESSORIES SEE MECHANICAL PLANS FOR ADDITIONAL INFO.
 - INSTALL NEW DRINKING FOUNTAINS REFER TO MECHANICAL PLANS FOR ADDITIONAL INFO.
 - FILL EXISTING OPENING WITH METAL STUDS, GYP, AND STUCCO FLUSH WITH EXISTING ADJACENT SURFACES AND FINISHES.
 - PROVIDE NEW HANDRAILS SEE ENLARGED PLAN FOR DETAILS
 - MAINTAIN EXISTING 1 HOUR FIRE RATING WHEN MODIFYING WALL

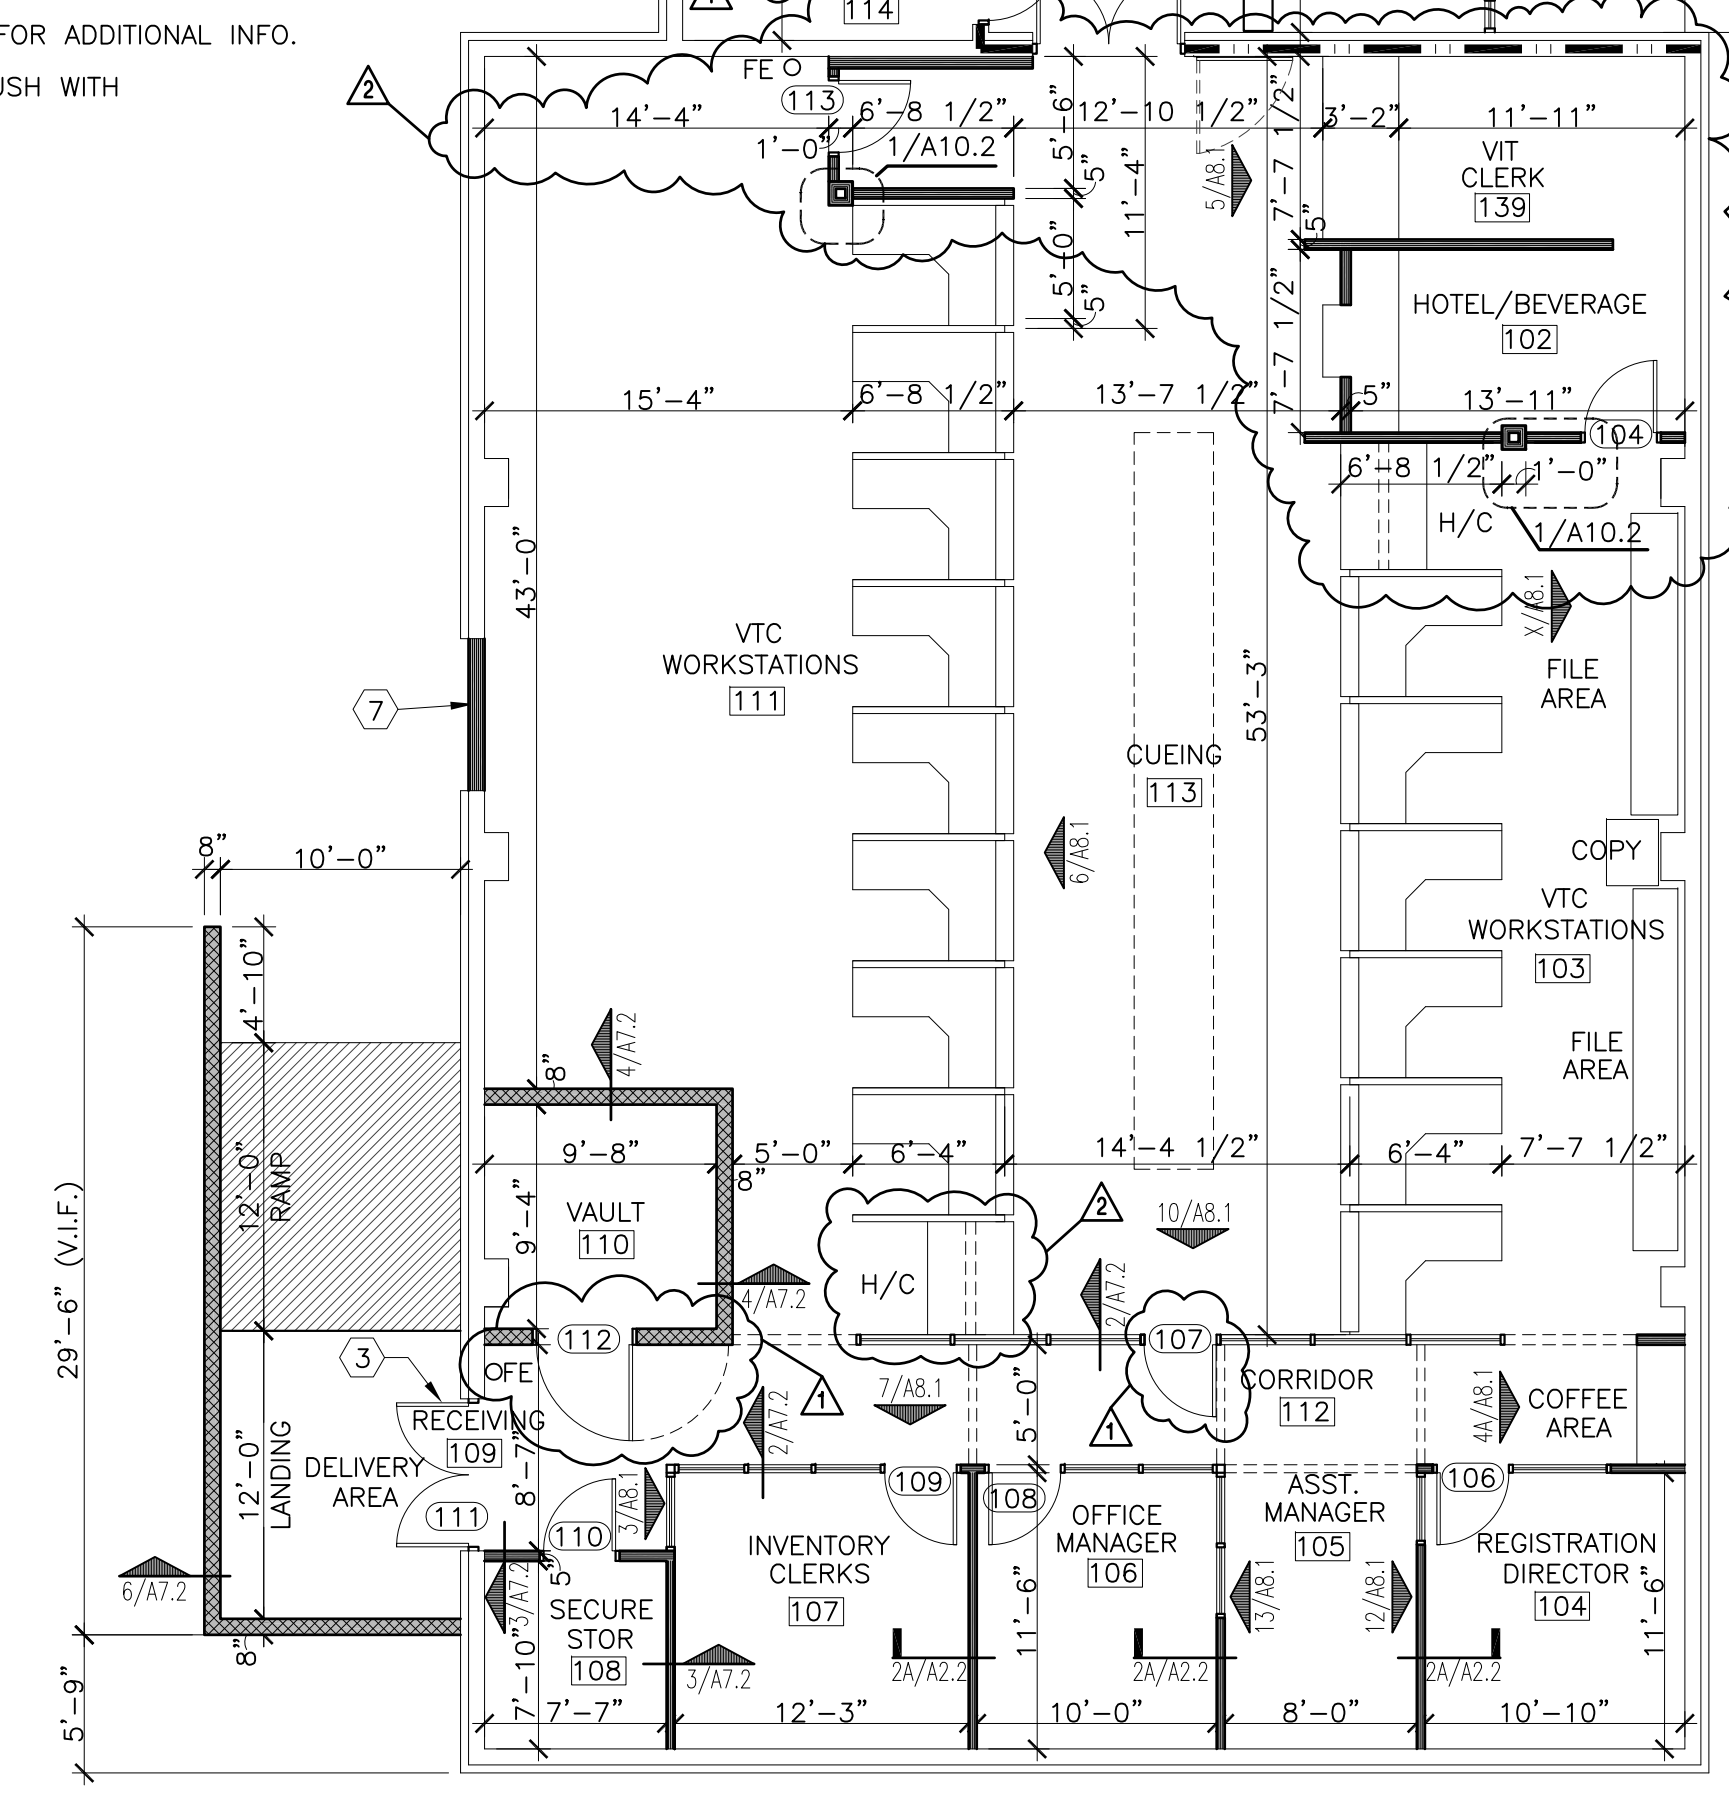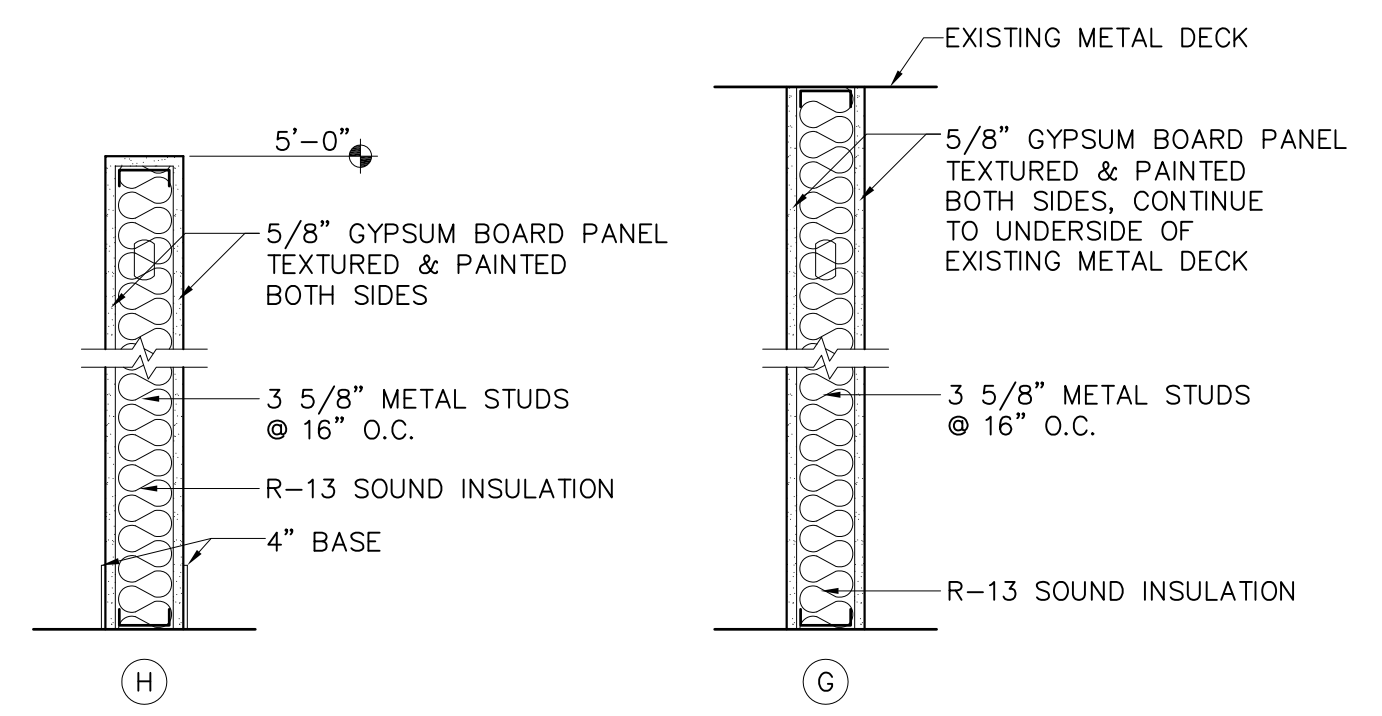

2 WALL TYPES
 SCALE: 1" = 1'-0"

 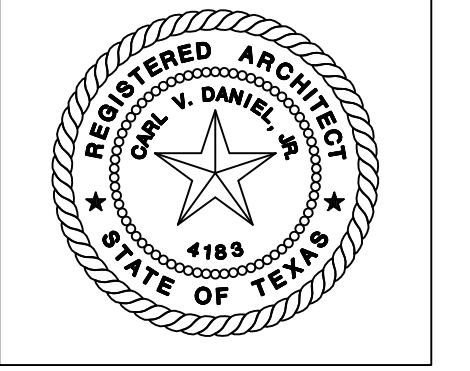

ISSUED FOR CONSTRUCTION

NO.	DATE	REVISION
△	04/03/2014	ADA REVISION
△	04/21/2014	REVISED
DATE: FEBRUARY 17, 2014		


SHEET:
A2.3
 REVISED 2ND FLOOR PLAN

ROOM FINISH SCHEDULE


NO.	ROOM NAME	FLOOR	BASE	WALLS				CEILING	REMARKS
				SOUTH	WEST	NORTH	EAST		
201	WAITING	12"x12" VCT	CERAMIC	PAINT	PAINT	PAINT	PAINT	2'x4' ACOUSTICAL	
202	OPEN SPACE	12"x12" VCT	4" COVED, VINYL	PAINT	PAINT	PAINT	PAINT	2'x4' ACOUSTICAL	
203	NOT USED								
204	NOT USED								
205	NOT USED								
206	STORAGE	12"x12" VCT	4" COVED, VINYL	PAINT	PAINT	PAINT	PAINT	2'x4' ACOUSTICAL	
207	WOMEN	12"x12" VCT	TILE	TILE	TILE	TILE	TILE	2'x4' ACOUSTICAL	
208	JANITOR	12"x12" VCT	4" COVED, VINYL	PAINT	PAINT	PAINT	PAINT	2'x4' ACOUSTICAL	
209	STORAGE	12"x12" VCT	4" COVED, VINYL	PAINT	PAINT	PAINT	PAINT	2'x4' ACOUSTICAL	
210	MEN	12"x12" VCT	TILE	TILE	TILE	TILE	TILE	2'x4' ACOUSTICAL	
211	CLASSROOM	12"x12" VCT	4" COVED, VINYL	PAINT	PAINT	PAINT	PAINT	2'x4' ACOUSTICAL	
212	CONFERENCE/CLASSROOM	12"x12" VCT	4" COVED, VINYL	PAINT	PAINT	PAINT	PAINT	2'x4' ACOUSTICAL	
213	OFFICE	CARPET	4" COVED, VINYL	PAINT	PAINT	PAINT	PAINT	2'x4' ACOUSTICAL	
214	OFFICE	CARPET	4" COVED, VINYL	PAINT	PAINT	PAINT	PAINT	2'x4' ACOUSTICAL	
215	OFFICE	CARPET	4" COVED, VINYL	PAINT	PAINT	PAINT	PAINT	2'x4' ACOUSTICAL	
216	OFFICE	CARPET	4" COVED, VINYL	PAINT	PAINT	PAINT	PAINT	2'x4' ACOUSTICAL	
217	OFFICE	CARPET	4" COVED, VINYL	PAINT	PAINT	PAINT	PAINT	2'x4' ACOUSTICAL	
218	OFFICE	CARPET	4" COVED, VINYL	PAINT	PAINT	PAINT	PAINT	2'x4' ACOUSTICAL	
219	IT ROOM	12"x12" VCT	4" COVED, VINYL	PAINT	PAINT	PAINT	PAINT	2'x4' ACOUSTICAL	
220	OFFICE	CARPET	4" COVED, VINYL	PAINT	PAINT	PAINT	PAINT	2'x4' ACOUSTICAL	
221	OFFICE	CARPET	4" COVED, VINYL	PAINT	PAINT	PAINT	PAINT	2'x4' ACOUSTICAL	
222	OFFICE	CARPET	4" COVED, VINYL	PAINT	PAINT	PAINT	PAINT	2'x4' ACOUSTICAL	
223	OFFICE	CARPET	4" COVED, VINYL	PAINT	PAINT	PAINT	PAINT	2'x4' ACOUSTICAL	
224	FILES	CARPET	4" COVED, VINYL	PAINT	PAINT	PAINT	PAINT	2'x4' ACOUSTICAL	
225	FILES	CARPET	4" COVED, VINYL	PAINT	PAINT	PAINT	PAINT	2'x4' ACOUSTICAL	
226	NOT USED								
227	NOT USED								
228	COPY/ PRINT	12"x12" VCT	CERAMIC	PAINT	PAINT	PAINT	PAINT	2'x4' ACOUSTICAL	
229	COPY/ PRINT	12"x12" VCT	4" COVED, VINYL	PAINT	PAINT	PAINT	PAINT	2'x4' ACOUSTICAL	
230	EXISTING CORRIDOR	12"x12" VCT	4" COVED, VINYL	PAINT	PAINT	PAINT	PAINT	2'x4' ACOUSTICAL	
231	STORAGE	12"x12" VCT	4" COVED, VINYL	PAINT	PAINT	PAINT	PAINT	2'x4' ACOUSTICAL	
232	NOT USED								
233	EXISTING STAIRS 1	12"x12" VCT	4" COVED, VINYL	PAINT	PAINT	PAINT	PAINT	2'x4' ACOUSTICAL	
234	EXISTING STAIRS 2	12"x12" VCT	4" COVED, VINYL	PAINT	PAINT	PAINT	PAINT	2'x4' ACOUSTICAL	

REMARKS:

- VCT FLOORING ACCENT COLOR FROM MANUFACTURER'S STANDARD COLORS, NOT TO EXCEED 10% OF TOTAL FLOOR INSTALLED, RANDOM PATTERN T.B.D. BY ARCHITECT, CORRIDOR ONLY.
- PRE-FORMED OUTSIDE CORNER GUARDS. PROVIDE AND INSTALL ABOVE CERAMIC WAINSCOT TO UNDERSIDE OF CEILING.
- PROVIDE & INSTALL FULL HEIGHT PRE-FORMED OUTSIDE CORNER GUARDS.
- CERAMIC WAINSCOT TO 54" A.F.F. INCLUDE BULL NOSE TRIM FOR TOP EDGE AND COVED BASE. PAINT AND TEXTURE ABOVE WAINSCOT TO 6" ABOVE CEILING HEIGHT.
- WALL TEXTURE FOR ALL INTERIOR WALLS SHALL BE "ORANGE PEEL", CONTRACTOR TO PROVIDE A SAMPLE FOR APPROVAL BY THE ARCHITECT BEFORE EXECUTING THE WORK.

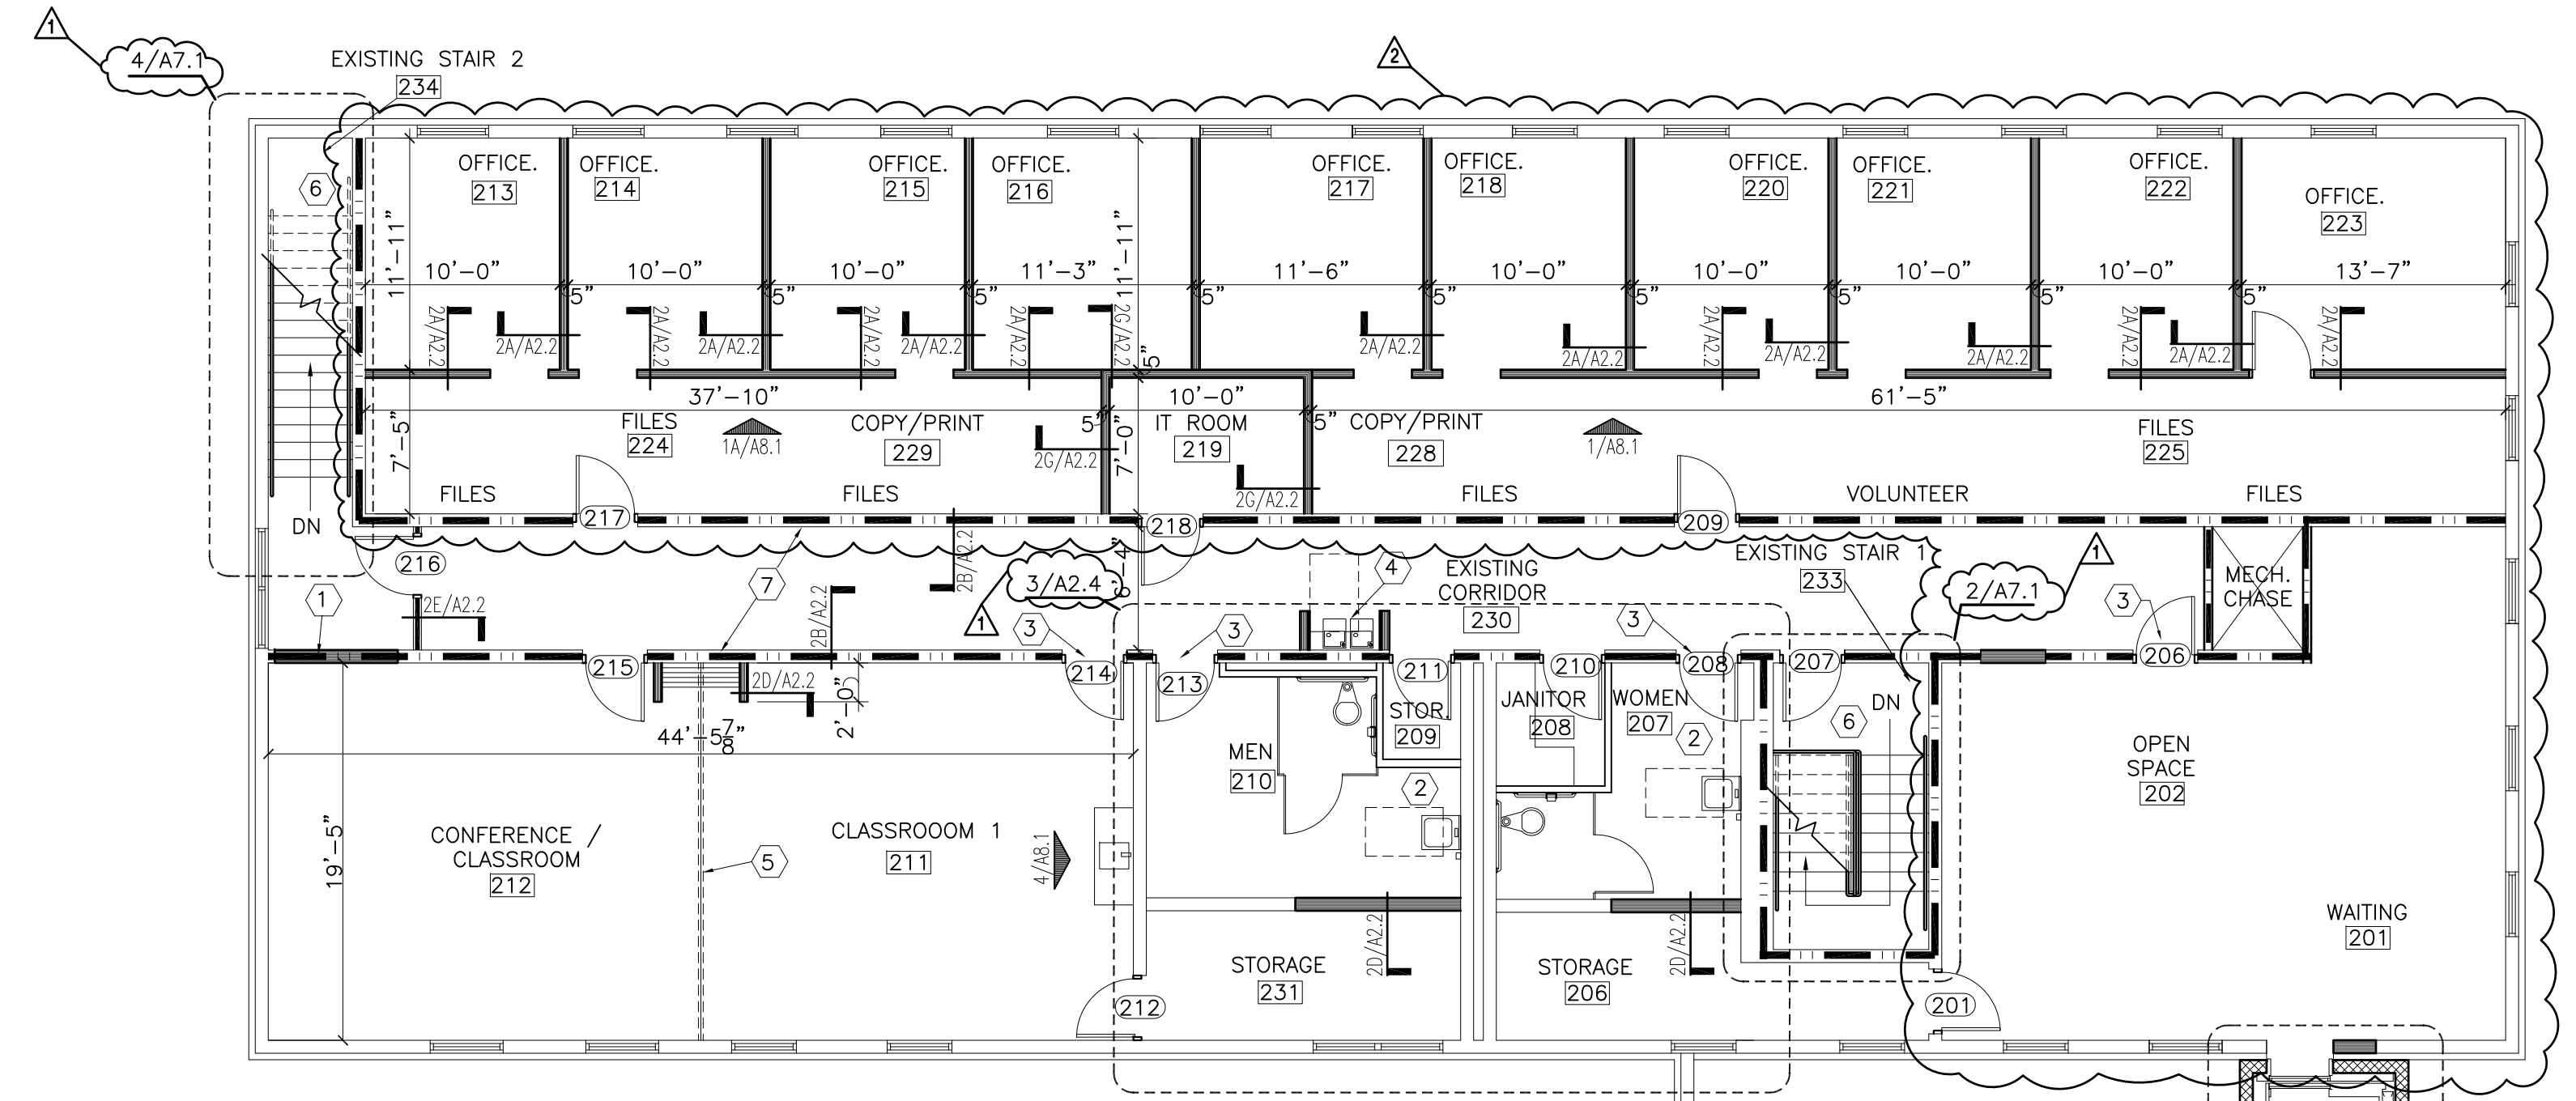

- REMODELING NOTES**
- FILL EXISTING DOOR OPENING WITH METAL STUDS AND GYP FLUSH WITH EXISTING ADJACENT SURFACES AND FINISHES. INSURE PATCH IS 1 HR. RATED
 - INSTALL ALL NEW FIXTURES AND ACCESSORIES SEE MECHANICAL PLANS FOR ADDITIONAL INFO.
 - ENLARGE EXISTING DOOR OPENING TO ACCOMMODATE NEW SCHEDULED DOOR PATCH AND REPAIR REMAINING SURFACES TO MATCH EXISTING ADJACENT SURFACES
 - INSTALL NEW DRINKING FOUNTAINS REFER TO MECHANICAL PLANS FOR ADDITIONAL INFO.
 - INSTALL NEW FOLDING PARTITION SEE ENLARGED DETAILS
 - PROVIDE NEW HANDRAILS SEE ENLARGED PLAN FOR DETAILS
 - MAINTAIN EXISTING 1 HOUR FIRE RATING WHEN MODIFYING WALL

 

1 REVISED SECOND FLOOR PLAN
 SCALE: 1/8" = 1'-0"