
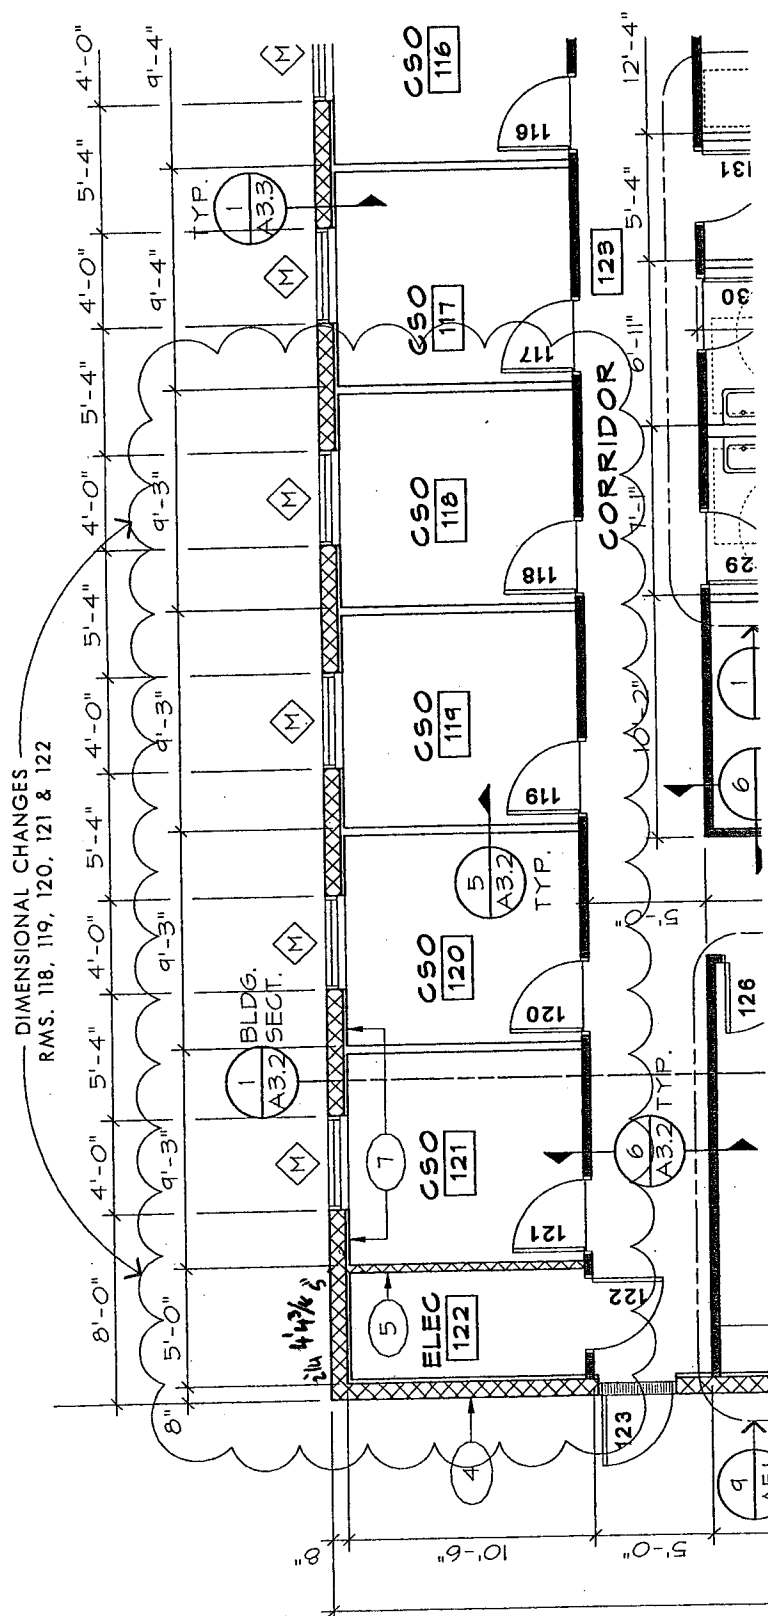


NORTHWEST ANNEX
FOR
THE COUNTY OF EL PASO
435 VINTON ROAD
VINTON, TEXAS


DATE: 10/24/2013
PROJ NO.: 4.0307

**SUPPLEMENTAL
DRAWING**

2


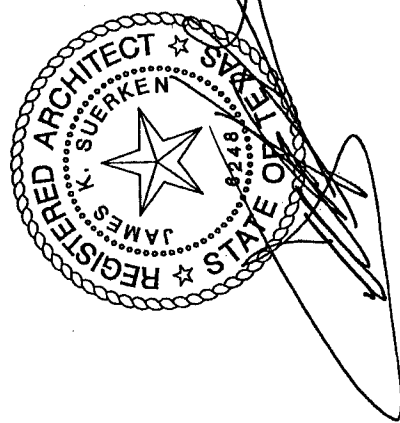


ADULT PROBATION
PARTIAL FLOOR PLAN

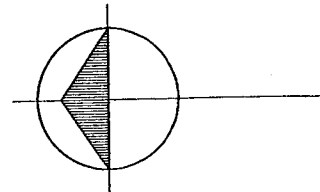



1/8" = 1'-0"

\\G:\proj\1 CAD\1 CAD\6\proj\NW ANNEX DD FFE.gxd
10/14/2011 10:48:21

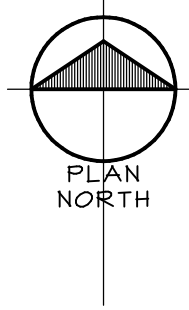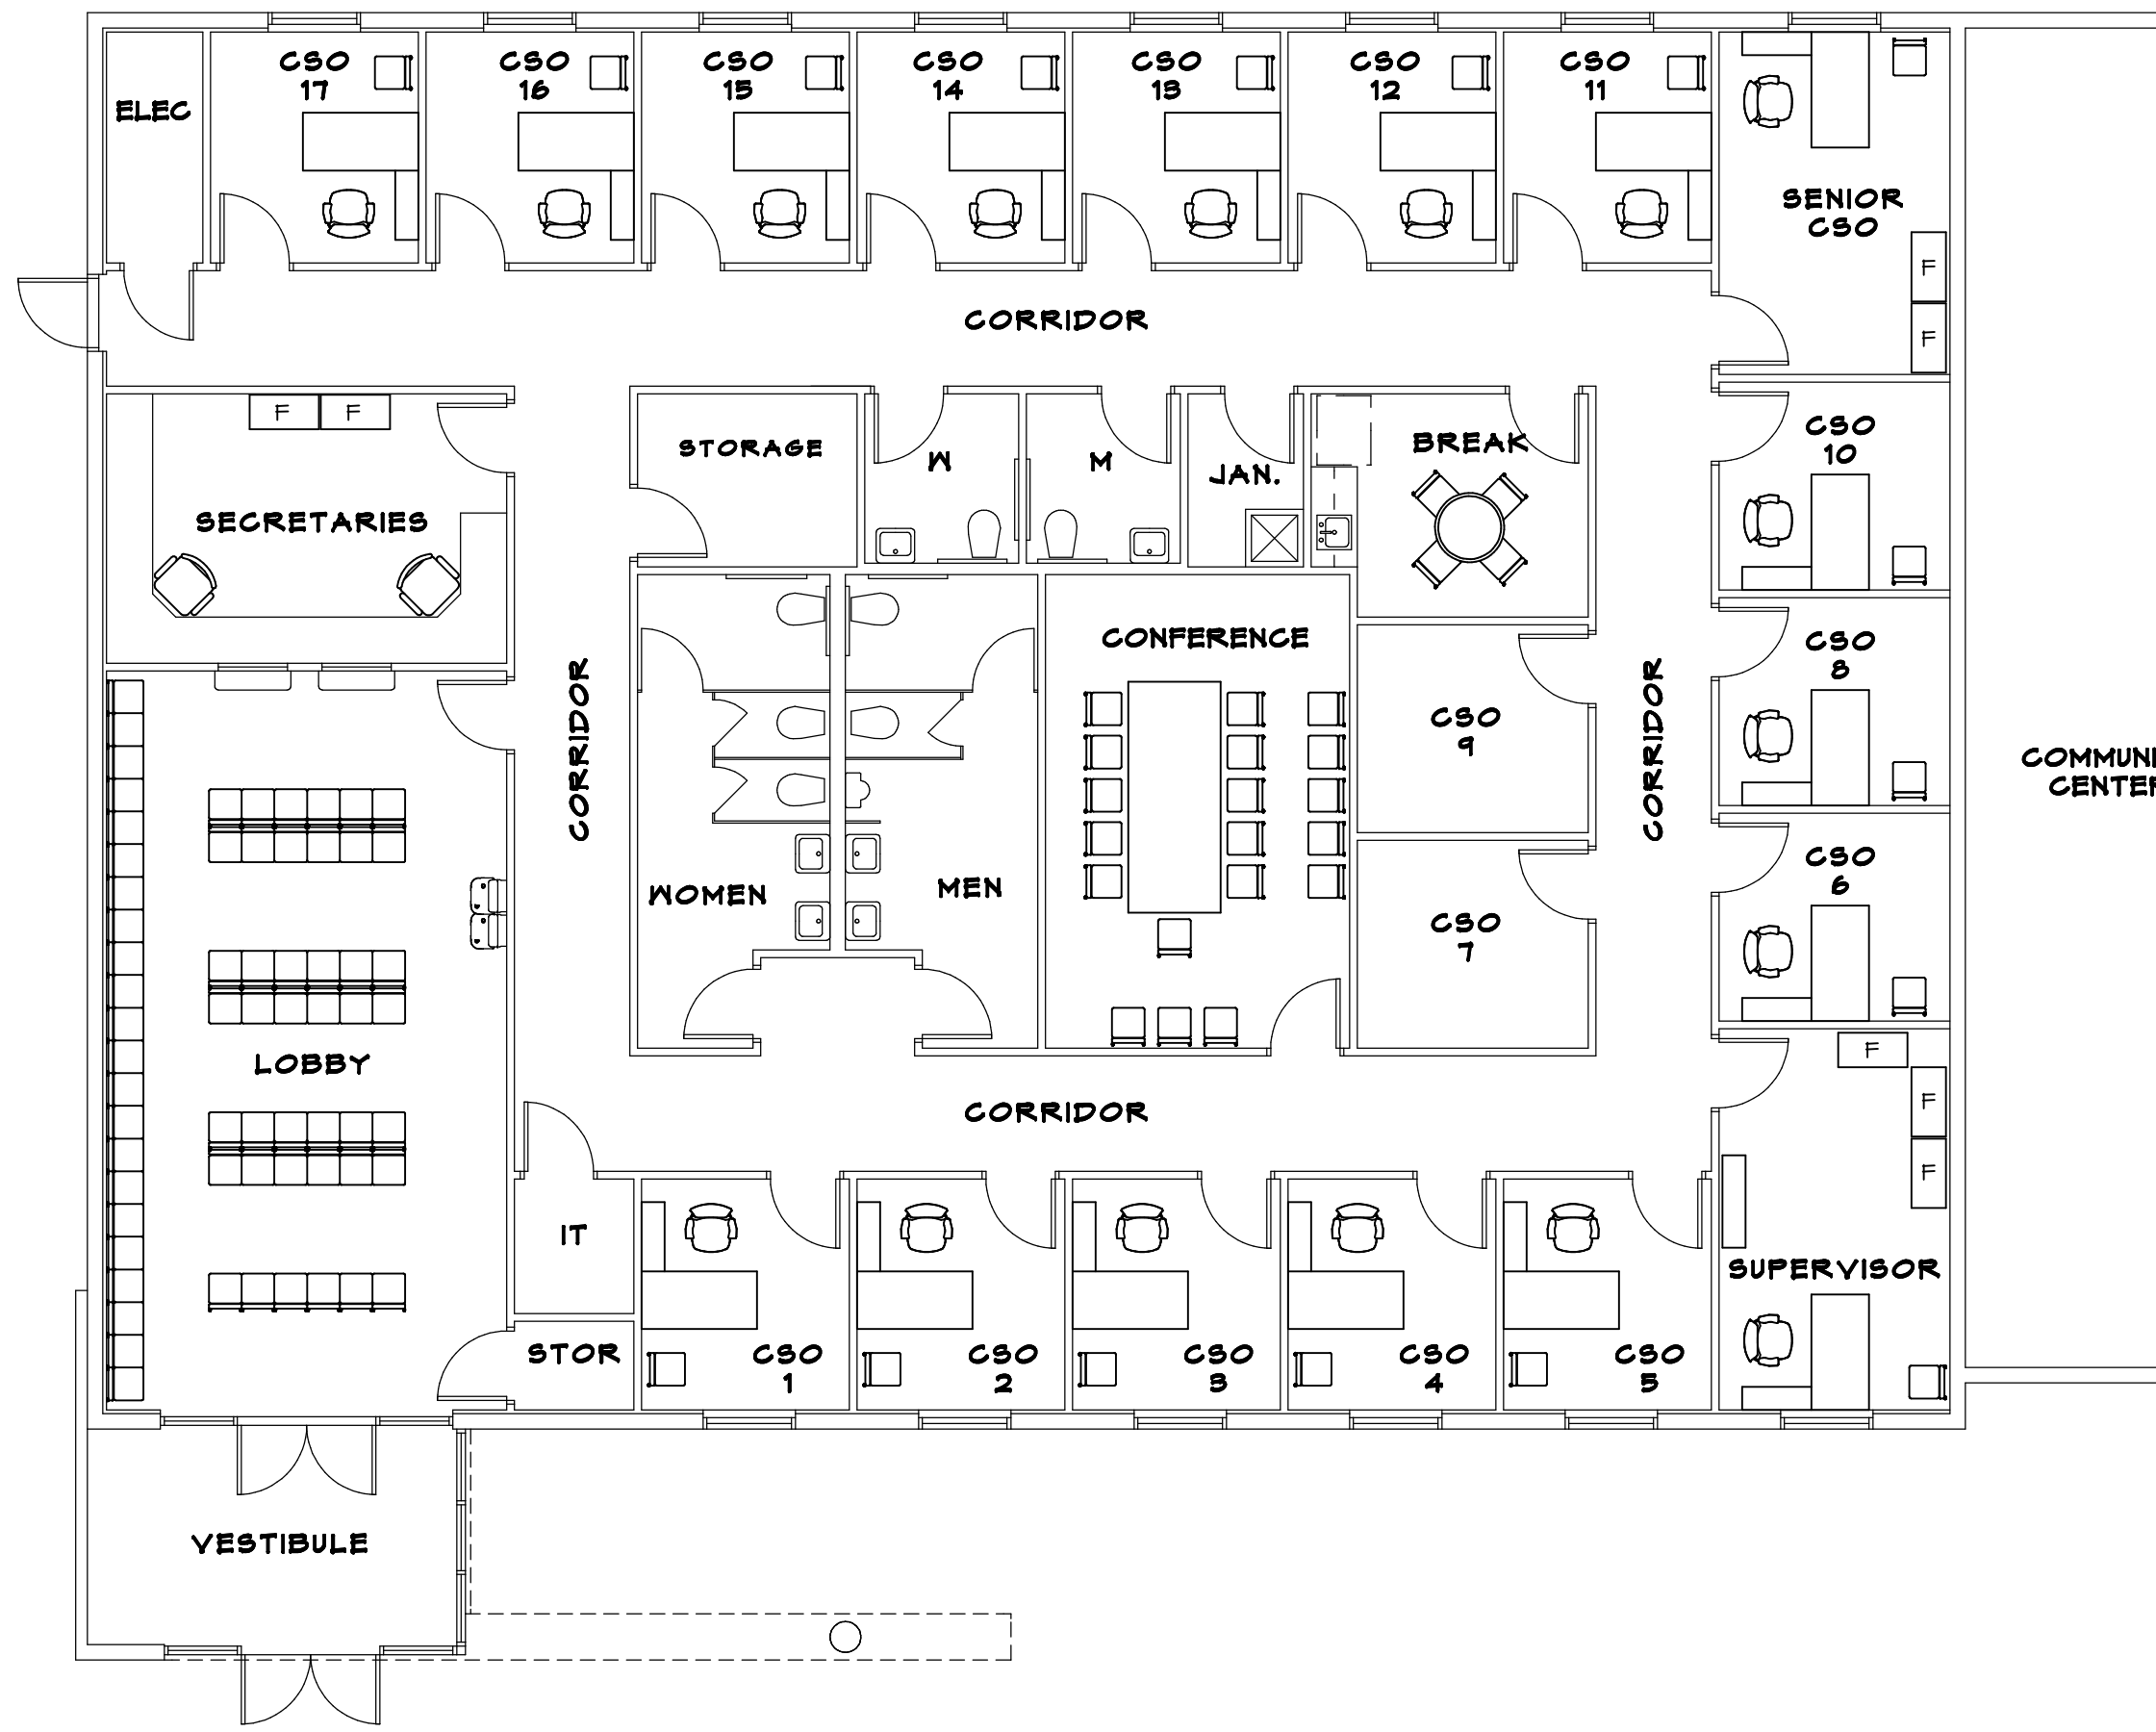



ADULT PROBATION OFFICE FLOOR PLAN

1/8" = 1'-0"

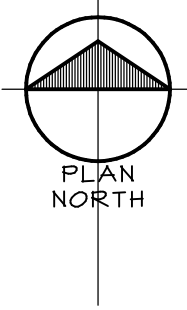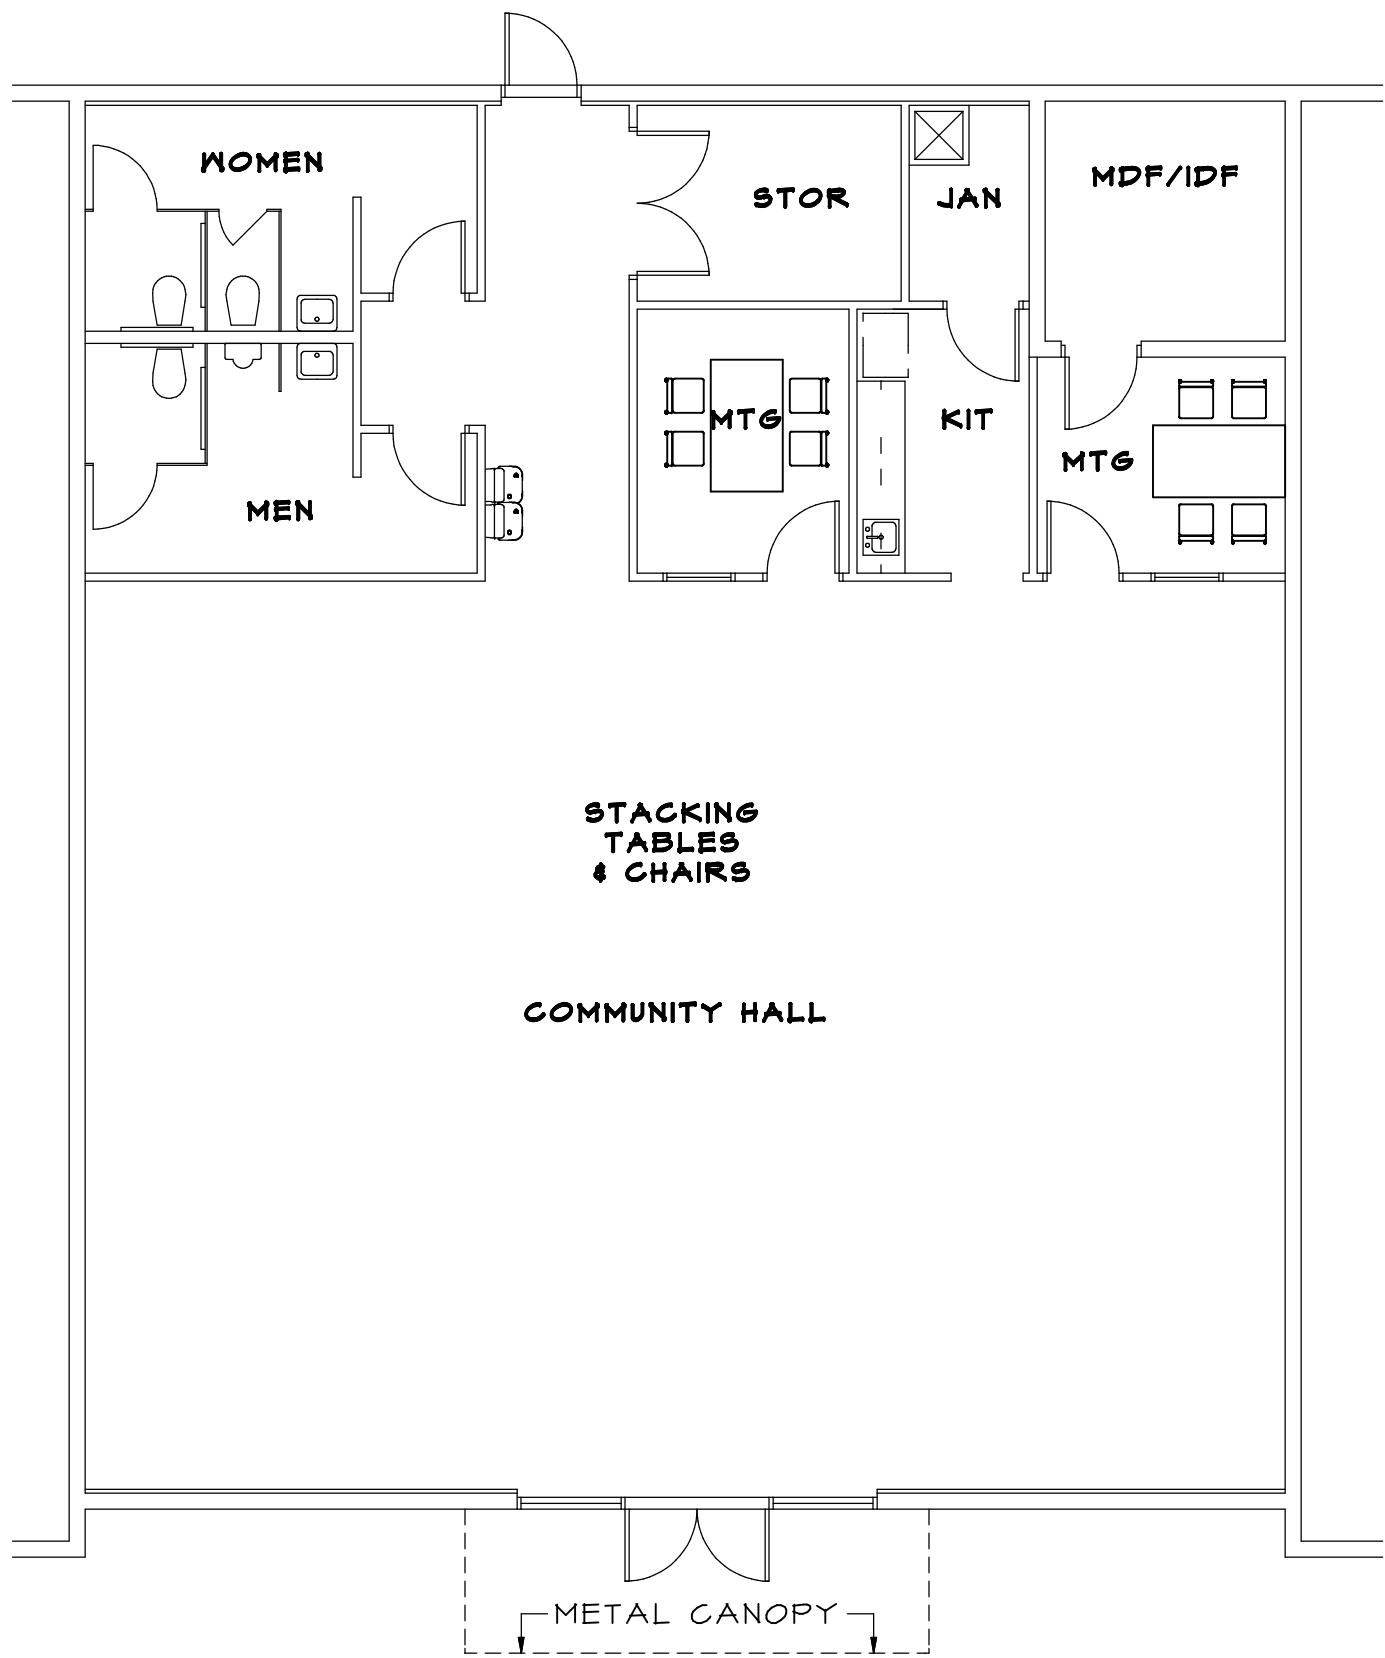



COMMUNITY CENTER FLOOR PLAN

1/8" = 1'-0"

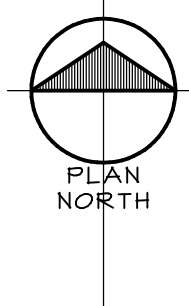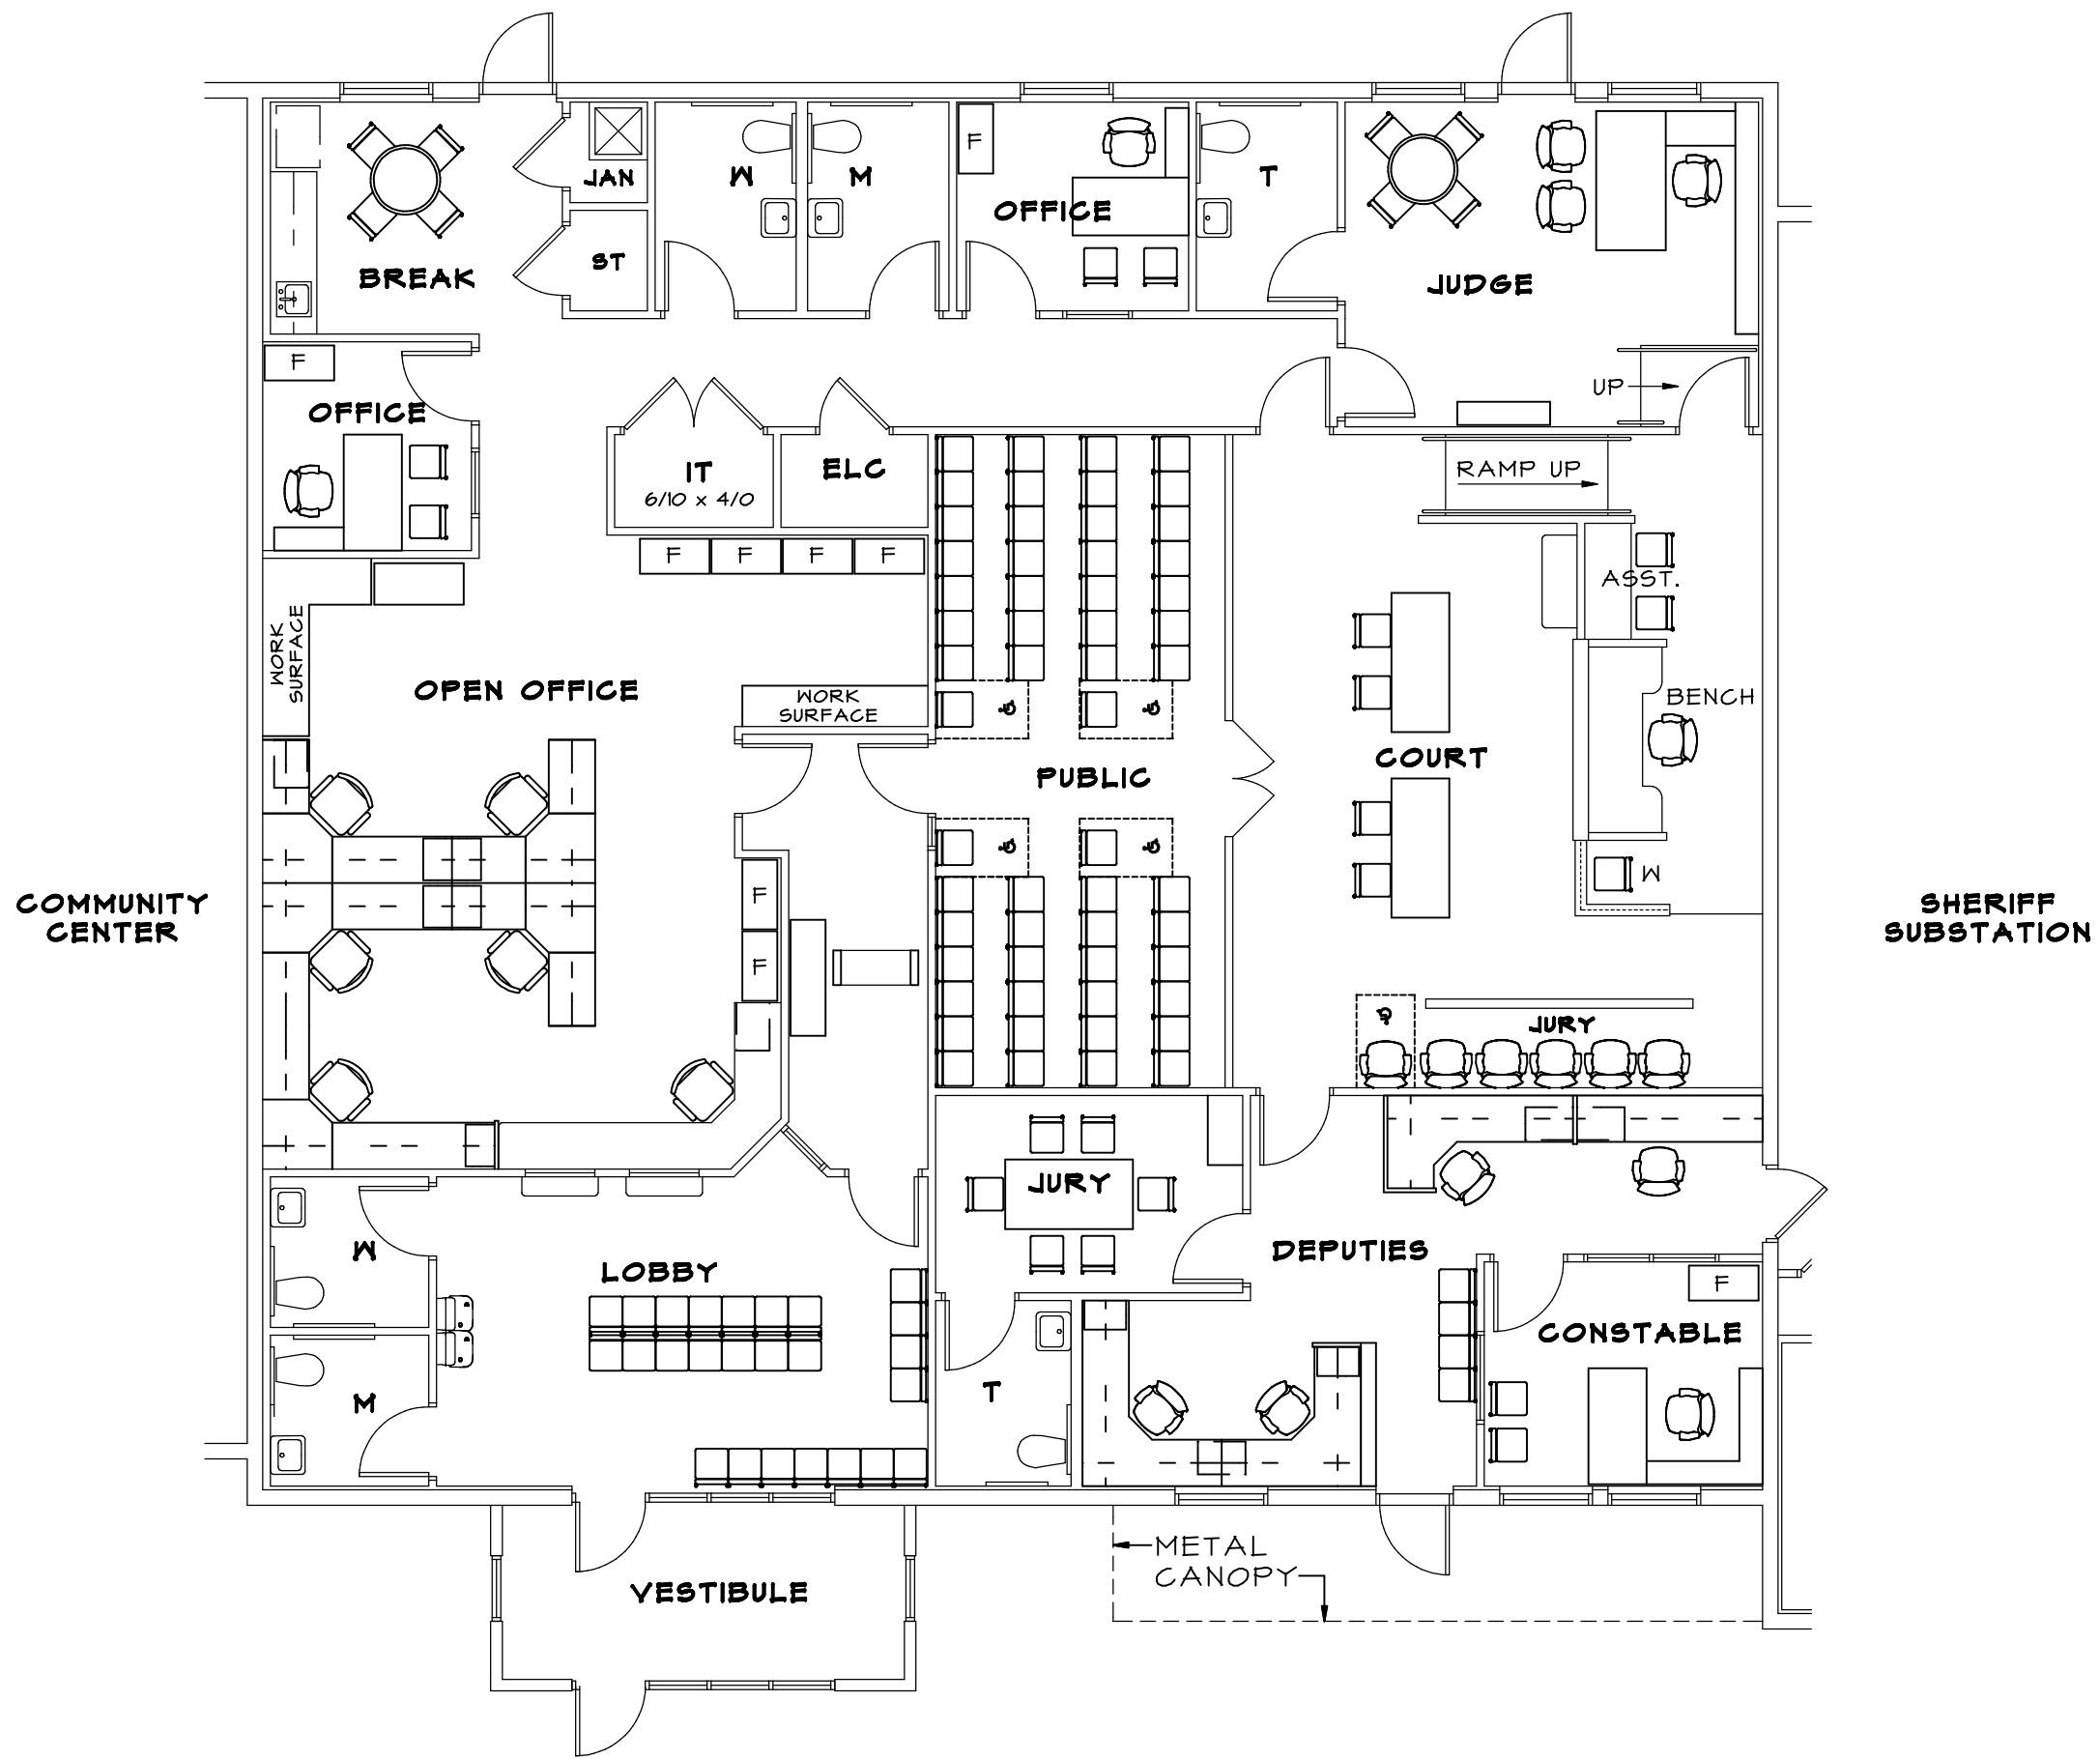

JP COURT & CONSTABLE FLOOR PLAN

1/8" = 1'-0"

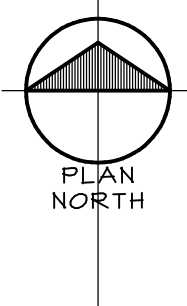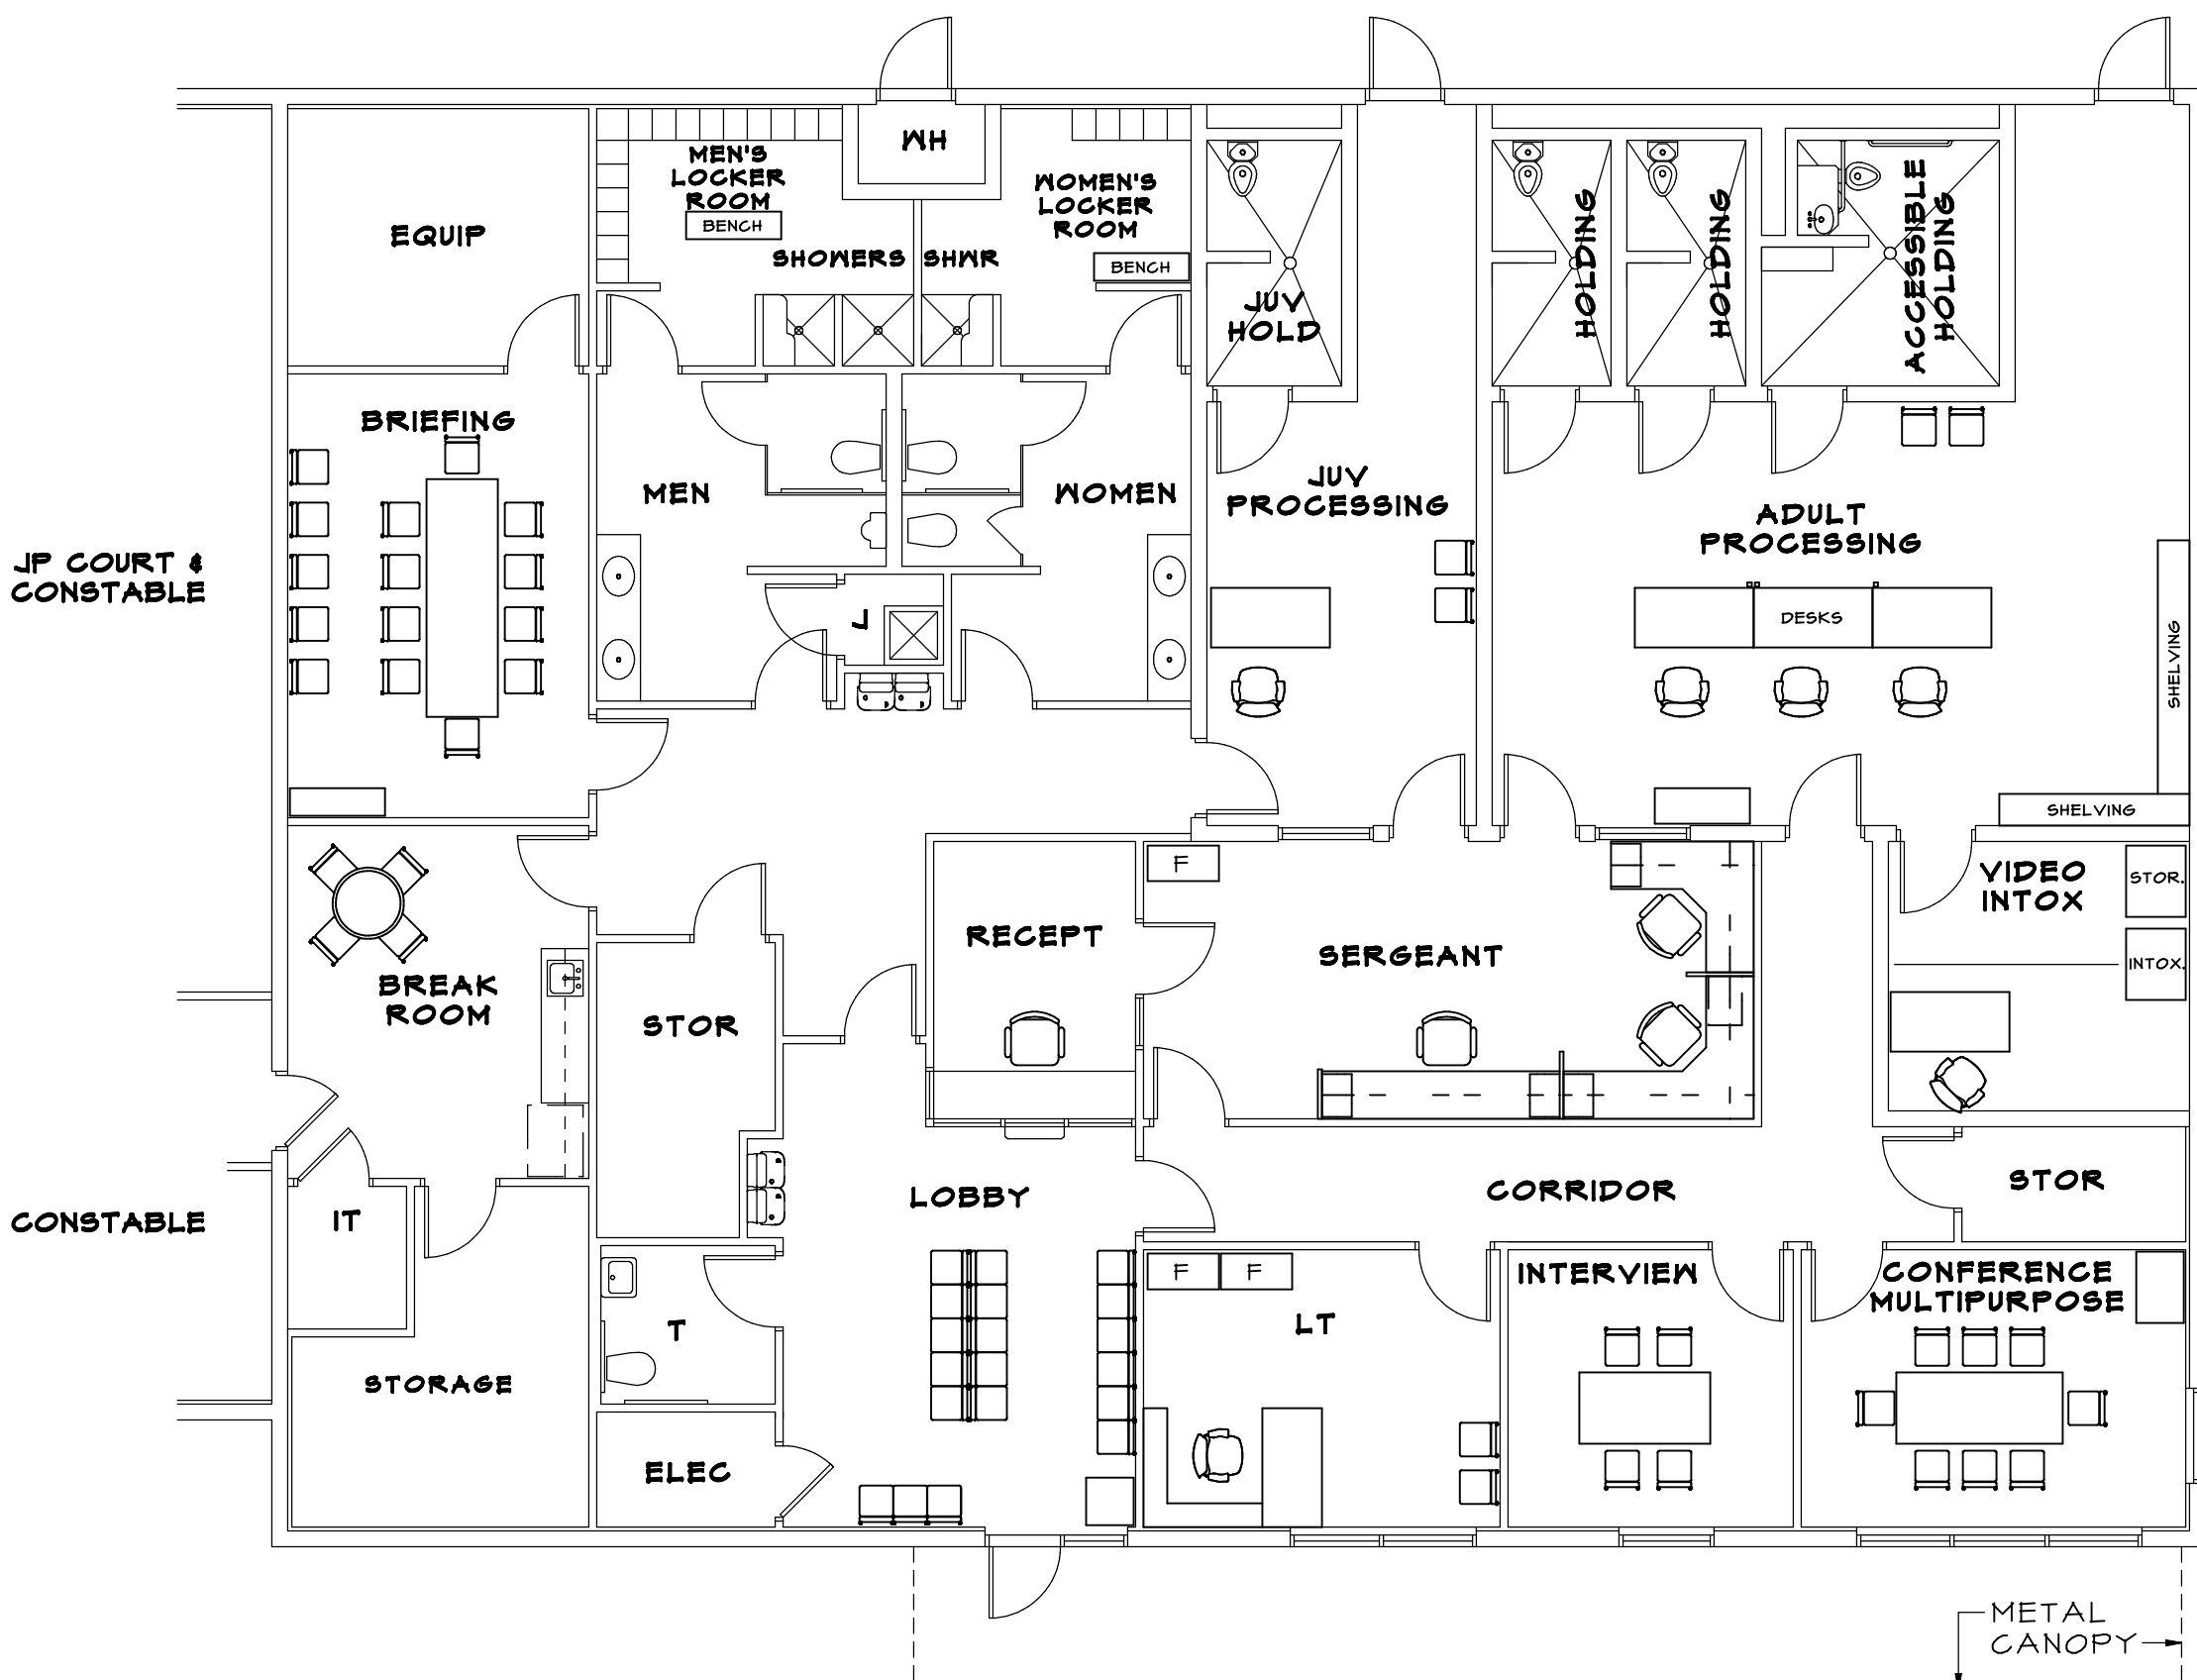

SHERIFF SUBSTATION FLOOR PLAN

1/8" = 1'-0"

PROPOSED FURNITURE PLAN

SMS
ARCHITECTS


7500 VISCOUNT
SUITE 125
EL PASO, TEXAS
79925
(915) 779-3048
FAX (915) 775-0703

JAMES K. SUBEREN
ARCHITECT
TEXAS REG. #6248
INCOMPLETE DRAWING
NOT FOR REGULATORY
APPROVAL, PERMIT OR
CONSTRUCTION

NORTHWEST ANNEX
FOR
THE COUNTY OF EL PASO
435 VINTON ROAD
VINTON, TEXAS

REVISIONS
△
△
△
△
DRAWN BY: STAFF
CHECKED BY: STAFF
DATE: 10/13/2011
PROJ. NO.: 9.0301

FURNITURE
PLAN

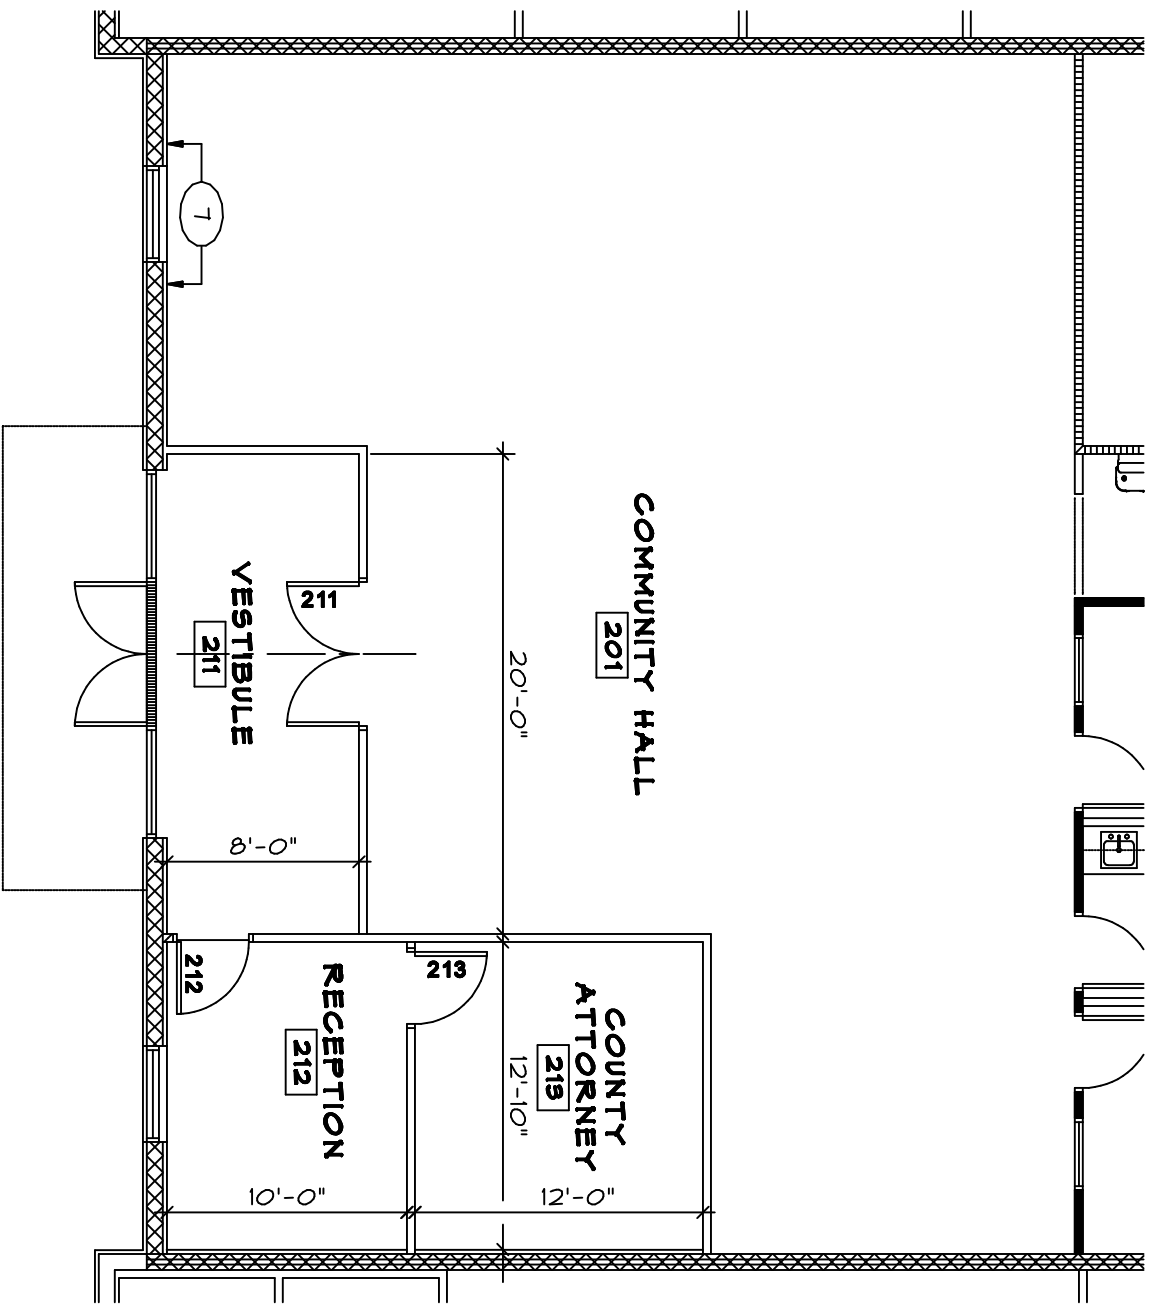

REVISED COMMUNITY CENTER
PARTIAL FLOOR PLAN

12-10-13


1/8" = 1'-0"

JAMES C. GURKEN
TEXAS REG. 76248
INCOMPLETE DRAWING
NOT FOR REGULATORY
APPROVAL, PERMIT OR
CONSTRUCTION

DOOR SCHEDULE															ADULT PROBATION OFFICE									
MARK	DOOR					HARDWARE SECTION & NO	FRAME					FIRE RATING	REMARKS											
	SIZE IN THK. UNO.	TYPE	MAT'L.	FINISH	GLASS		TYPE	MAT'L.	FINISH	HEAD	JAMB			SILL										
101	2-3/0 x 7/0	I	AL	AN	TP	001	A	AL	CA	1/A2.4	-	3/A2.4	-	1										
102	2-3/0 x 7/0	I	AL	AN	TP	001	B	AL	CA	5/A2.4	-	6/A2.4	-											
103	3/0 x 7/0	II	SC	TF	-	004	G	HM	PTD	12/A2.4	B/A2.4	-	20 MIN											
104	3/0 x 7/0	II	SC	TF	-	004	G	HM	PTD	12/A2.4	B/A2.4	-	20 MIN											
105	3/0 x 7/0	III	SC	TF	FR	008	G	HM	PTD	12/A2.4	B/A2.4	-	20 MIN											
106	3/0 x 7/0	III	SC	TF	FR	008	G	HM	PTD	12/A2.4	B/A2.4	-	20 MIN											
107	3/0 x 7/0	III	SC	TF	FR	008	G	HM	PTD	12/A2.4	B/A2.4	-	20 MIN											
108	3/0 x 7/0	III	SC	TF	FR	008	G	HM	PTD	12/A2.4	B/A2.4	-	20 MIN											
109	3/0 x 7/0	III	SC	TF	FR	008	G	HM	PTD	12/A2.4	B/A2.4	-	20 MIN											
110	3/0 x 7/0	III	SC	TF	FR	008	G	HM	PTD	12/A2.4	B/A2.4	-	20 MIN											
111	3/0 x 7/0	III	SC	TF	FR	008	G	HM	PTD	12/A2.4	B/A2.4	-	20 MIN											
112	3/0 x 7/0	III	SC	TF	FR	008	G	HM	PTD	12/A2.4	B/A2.4	-	20 MIN											
113	3/0 x 7/0	III	SC	TF	FR	008	G	HM	PTD	12/A2.4	B/A2.4	-	20 MIN											
114	3/0 x 7/0	III	SC	TF	FR	008	G	HM	PTD	12/A2.4	B/A2.4	-	20 MIN											
115	3/0 x 7/0	III	SC	TF	FR	008	G	HM	PTD	12/A2.4	B/A2.4	-	20 MIN											
116	3/0 x 7/0	III	SC	TF	FR	008	G	HM	PTD	12/A2.4	B/A2.4	-	20 MIN											
117	3/0 x 7/0	III	SC	TF	FR	008	G	HM	PTD	12/A2.4	B/A2.4	-	20 MIN											
118	3/0 x 7/0	III	SC	TF	FR	008	G	HM	PTD	12/A2.4	B/A2.4	-	20 MIN											
119	3/0 x 7/0	III	SC	TF	FR	008	G	HM	PTD	12/A2.4	B/A2.4	-	20 MIN											
120	3/0 x 7/0	III	SC	TF	FR	008	G	HM	PTD	12/A2.4	B/A2.4	-	20 MIN											
121	3/0 x 7/0	III	SC	TF	FR	008	G	HM	PTD	12/A2.4	B/A2.4	-	20 MIN											
122	3/0 x 7/0	II	SC	TF	-	004	G	HM	PTD	12/A2.4	B/A2.4	-	20 MIN											
123	3/0 x 7/0	IV	HM	PTD	-	002	F	HM	PTD	7/A2.4	8/A2.4	9/A2.4	-	1,2										
124	NOT USED																							
125	NOT USED																							
126	3/0 x 7/0	III	SC	TF	FR	008	G	HM	PTD	12/A2.4	B/A2.4	-	20 MIN											
127	3/0 x 7/0	III	SC	TF	FR	011	G	HM	PTD	12/A2.4	B/A2.4	-	20 MIN											
128	3/0 x 7/0	II	SC	TF	-	004	G	HM	PTD	12/A2.4	B/A2.4	-	20 MIN											
129	3/0 x 7/0	II	SC	TF	-	012	G	HM	PTD	12/A2.4	B/A2.4	-	20 MIN											
130	3/0 x 7/0	II	SC	TF	-	012	G	HM	PTD	12/A2.4	B/A2.4	-	20 MIN											
131	3/0 x 7/0	II	SC	TF	-	004	G	HM	PTD	12/A2.4	B/A2.4	-	20 MIN											
132	3/0 x 7/0	III	SC	TF	FR	013	G	HM	PTD	12/A2.4	B/A2.4	-	20 MIN											
133	3/0 x 7/0	III	SC	TF	FR	008	G	HM	PTD	12/A2.4	B/A2.4	-	20 MIN											
134	3/0 x 7/0	III	SC	TF	FR	008	G	HM	PTD	12/A2.4	B/A2.4	-	20 MIN											
135	3/0 x 7/0	III	SC	TF	FR	008	G	HM	PTD	12/A2.4	B/A2.4	-	20 MIN											
136	3/0 x 7/0	II	SC	TF	-	010	G	HM	PTD	12/A2.4	B/A2.4	-	-											
137	3/0 x 7/0	II	SC	TF	-	010	G	HM	PTD	12/A2.4	B/A2.4	-	-											

DOOR SCHEDULE COMMUNITY CENTER														
MARK	DOOR					HARDWARE SECTION & NO.	FRAME						FIRE RATING	REMARKS
	SIZE 1/4" THK. U.N.O.	TYPE	MAT'L.	FINISH	GLASS		TYPE	MAT'L.	FINISH	HEAD	JAMB	SILL		
201	2-3/0 x 7/0	I	AL	AN	TP	001	C	AL	CA	10/A2.4	-	3/A2.4	-	1
202	3/0 x 7/0	IV	HM	PTD	-	003	F	HM	PTD	7/A2.4	B/A2.4	9/A2.4	-	1 & 2
203	3/0 x 7/0	II	SC	TF	-	010	G	HM	PTD	12/A2.4	B/A2.4	-	-	
204	3/0 x 7/0	II	SC	TF	-	010	G	HM	PTD	12/A2.4	B/A2.4	-	-	
205	2-3/0 x 7/0	II	SC	TF	-	014	H	HM	PTD	12/A2.4	B/A2.4	-	20 MIN	
206	3/0 x 7/0	II	SC	TF	-	004	G	HM	PTD	12/A2.4	B/A2.4	-	-	
207	3/0 x 7/0	II	SC	TF	-	004	F	HM	PTD	14/A2.4	B/A2.4	-	-	
208	3/0 x 7/0	II	SC	TF	-	008	G	HM	PTD	12/A2.4	B/A2.4	-	20 MIN	
209	3/0 x 7/0	II	SC	TF	-	011	G	HM	PTD	12/A2.4	B/A2.4	-	20 MIN	
210	3/0 x 7/0	II	SC	TF	-	008	G	HM	PTD	12/A2.4	B/A2.4	-	20 MIN	
	</													

REMARKS
1. SEE DETAIL 1/A2.0 FOR REQUIRED MANEUVERING CLEARANCES AT EXTERIOR DOORS.
2. USE DOOR SCOPE AT THIS DOOR - DUSEUNG DS/1000 MG-BREY

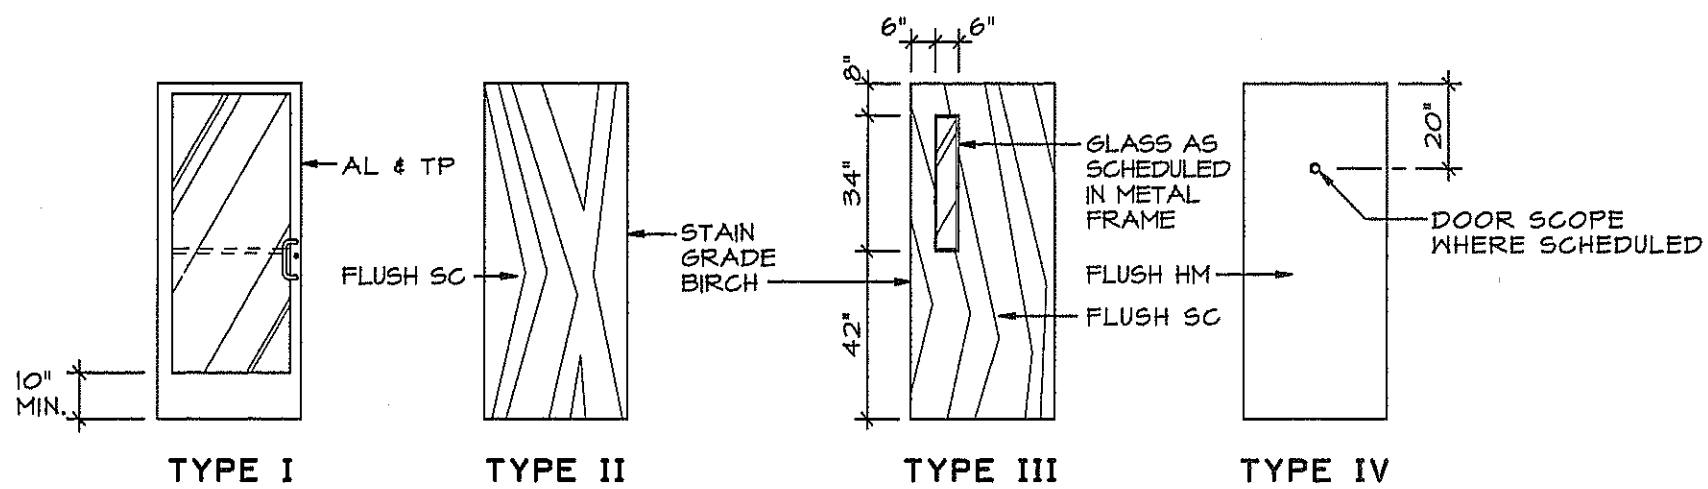

DOOR TYPES

N.T.S.

ABBREVIATIONS

AL ALUMINUM
AN ANODIZED
FR FIRE RESISTANCE RATED GLAZING
HM HOLLOW METAL
MFR MANUFACTURER
PTD PAINTED
SC SOLID CORE WOOD
STL STEEL
TF TRANSPARENT FINISH
TP 1/4" TEMPERED PLATE GLASS

KEYNOTES THIS SHEET

- PROVIDE 2 1/2" SOUND ATTENUATING BATT INSULATION THIS WALL FULL HEIGHT TYPICAL AT TOILET ROOMS & WHERE INDICATED
- GYP. BD. FINISH LAMINATED TO CMU
- FINISHED OPENING AT 7'-0" AFF
- SEE EXTERIOR ELEVATIONS AND TYPICAL WALL SECTIONS FOR ALL EXTERIOR FINISHES
- NON-RATED WALL FULL HEIGHT TO DECK
- TYP. PROVIDE TRANSITION STRIP AT FLOORING CHANGE
- TYPICAL AT EXTERIOR CMU WHERE INDICATED - 5/8" GYP. BD. ON 1 1/2" x 25 GA. STUDS @ 24" O.C. WITH 1 1/2" THK. FOAM CORE RIGID INSULATION BOARD


ROOM FINISH SCHEDULE								ADULT PROBATION OFFICE		
NO.	ROOM NAME	FLOOR	BASE	WALLS				CEILING	CLG. HGT.	REMARKS
				N	E	S	W			
101	VESTIBULE	F3	B2	NI	NI	NI	NI	C1	10'-0"	3
102	LOBBY	F1	B1	NI	NI	NI	NI	C1	10'-0"	
103	STORAGE	F1	B1	NI	NI	NI	NI	C1	9'-0"	
104	IT	F1	B1	NI	NI	NI	NI	C3	-	
105	C50	F2	B1	NI	NI	NI	NI	C1	9'-0"	
106	C50	F2	B1	NI	NI	NI	NI	C1	9'-0"	
107	C50	F2	B1	NI	NI	NI	NI	C1	9'-0"	
108	C50	F2	B1	NI	NI	NI	NI	C1	9'-0"	
109	C50	F2	B1	NI	NI	NI	NI	C1	9'-0"	
110	SUPERVISOR	F2	B1	NI	NI	NI	NI	C1	9'-0"	
111	C50	F2	B1	NI	NI	NI	NI	C1	9'-0"	
112	C50	F2	B1	NI	NI	NI	NI	C1	9'-0"	
113	C50	F2	B1	NI	NI	NI	NI	C1	9'-0"	
114	SENIOR C50	F2	B1	NI	NI	NI	NI	C1	9'-0"	
115	C50	F2	B1	NI	NI	NI	NI	C1	9'-0"	
116	C50	F2	B1	NI	NI	NI	NI	C1	9'-0"	
117	C50	F2	B1	NI	NI	NI	NI	C1	9'-0"	
118	C50	F2	B1	NI	NI	NI	NI	C1	9'-0"	
119	C50	F2	B1	NI	NI	NI	NI	C1	9'-0"	
120	C50	F2	B1	NI	NI	NI	NI	C1	9'-0"	
121	C50	F2	B1	NI	NI	NI	NI	C1	9'-0"	
122	ELECTRICAL	F1	B1	NI	NI	NI	NI	C3	-	
123	CORRIDOR	F1	B1	NI	NI	NI	NI	C1	9'-0"	
124	CORRIDOR	F1	B1	NI	NI	NI	NI	C1	9'-0"	
125	CORRIDOR	F1	B1	NI	NI	NI	NI	C1	9'-0"	
126	CORRIDOR	F1	B1	NI	NI	NI	NI	C1	9'-0"	
127	SECRETARIES	F1	B1	NI	NI	NI	NI	C1	9'-0"	
128	STORAGE	F1	B1	NI	NI	NI	NI	C1	9'-0"	
129	WOMEN	F4	B3	NI	NI	NI	NI	C2	8'-0"	1
130	MEN	F4	B3	NI	NI	NI	NI	C2	8'-0"	1
131	JANITOR	F1	B1	NI	NI	NI	NI	C1	9'-0"	1 & 2
132	BREAK ROOM	F1	B1	NI	NI	NI	NI	C1	9'-0"	
133	C50	F2	B1	NI	NI	NI	NI	C1	9'-0"	
134	C50	F2	B1	NI	NI	NI	NI	C1	9'-0"	
135	CONFERENCE	F2	B1	NI	NI	NI	NI	C1	9'-0"	
136	MEN	F3	B2	W2	W2	W1	W1	C2	9'-0"	1 & 4
137	WOMEN	F3	B2	W2	W2	W1	W1	C2	9'-0"	1 & 4

ROOM FINISH SCHEDULE COMMUNITY CENTER										
NO.	ROOM NAME	FLOOR	BASE	WALLS				CEILING	CLG. HGT.	REMARKS
				N	E	S	W			
201	COMMUNITY HALL	F1	B1	W1	W1	W1	W1	C1	10'-0"	
202	CORRIDOR	F1	B1	W1	W1	W1	W1	C1	10'-0"	3
203	MEN	F3	B2	W2	W1	W1	W2	C2	9'-0"	1 & 4
204	WOMEN	F3	B2	W2	W1	W1	W2	C2	9'-0"	1 & 4
205	STORAGE	F1	B1	W1	W1	W1	W1	C1	9'-0"	
206	JANITOR	F1	B1	W1	W3	W1	W1	C1	9'-0"	2
207	MDP/IDF	F3	B4	W3	W3	W3	W3	C3	-	
208	MEETING	F1	B1	W1	W1	W1	W1	C1	9'-0"	
209	KITCHEN	F1	B1	W1	W1	W1	W1	C1	9'-0"	
210	MEETING	F1	B1	W1	W1	W1	W1	C1	9'-0"	

REMARKS
1. PROVIDE WATER-RESISTANT GYP. BD. AT ALL PLUMBING WALLS.
2. PROVIDE 48" HIGH FRP WAINSCOT - 36" EACH WAY FROM CORNER AT MOP SINK - FULL TRIM AT PERIMETER OF FRP - SEE INTERIOR ELEVATIONS
3. PROVIDE W2 TILE ON WALL BEHIND ENG'S - BULLNOSE ALL AROUND SEE ELEVATIONS
4. NO BASE AT TILED WALLS

ROOM FINISH KEY

KEY	DESCRIPTION
F1	12x12 VINYL COMPOSITION TILE (VCT)
F2	CARPET TILES
F3	12x12 PORCELAIN CERAMIC TILE
F4	PORCELAIN CERAMIC MOSAIC TILE
F5	CLEAN EXPOSED CONCRETE - FINISH WITH SEALER ONLY
F6	EPOXY FLOOR COATING
B1	4" VINYL BASE
B2	PORCELAIN CERAMIC STRAIGHT BASE
B3	PORCELAIN GMT COVE BASE
B4	NO BASE
W1	PAINTED GYP. BD. - TAPE, BED, TEXTURE, PRIME & PAINT
W2	PORCELAIN CERAMIC WALL TILE
W3	PAINTED CMU - BLOCK FILLER, PRIMER & PAINT
C1	2' x 4' LAY-IN MINERAL PANELS WITH SPECIFIED GRID
C1.2	2' x 2' LAY-IN REGULAR EDGE PANELS WITH SPECIFIED GRID
C1.3	2' x 2' CHROME GRID W/ ACRYLIC PARABOLIC CHROME LENS PANELS
C2	PAINTED GYP. BD. - TAPE, BED, TEXTURE, PRIME & PAINT
C3	CLEAN ALL STRUCTURAL ELEMENTS - NO FINISH REQUIRED
C4	CLEAN EXPOSED CONCRETE - PAINT FINISH

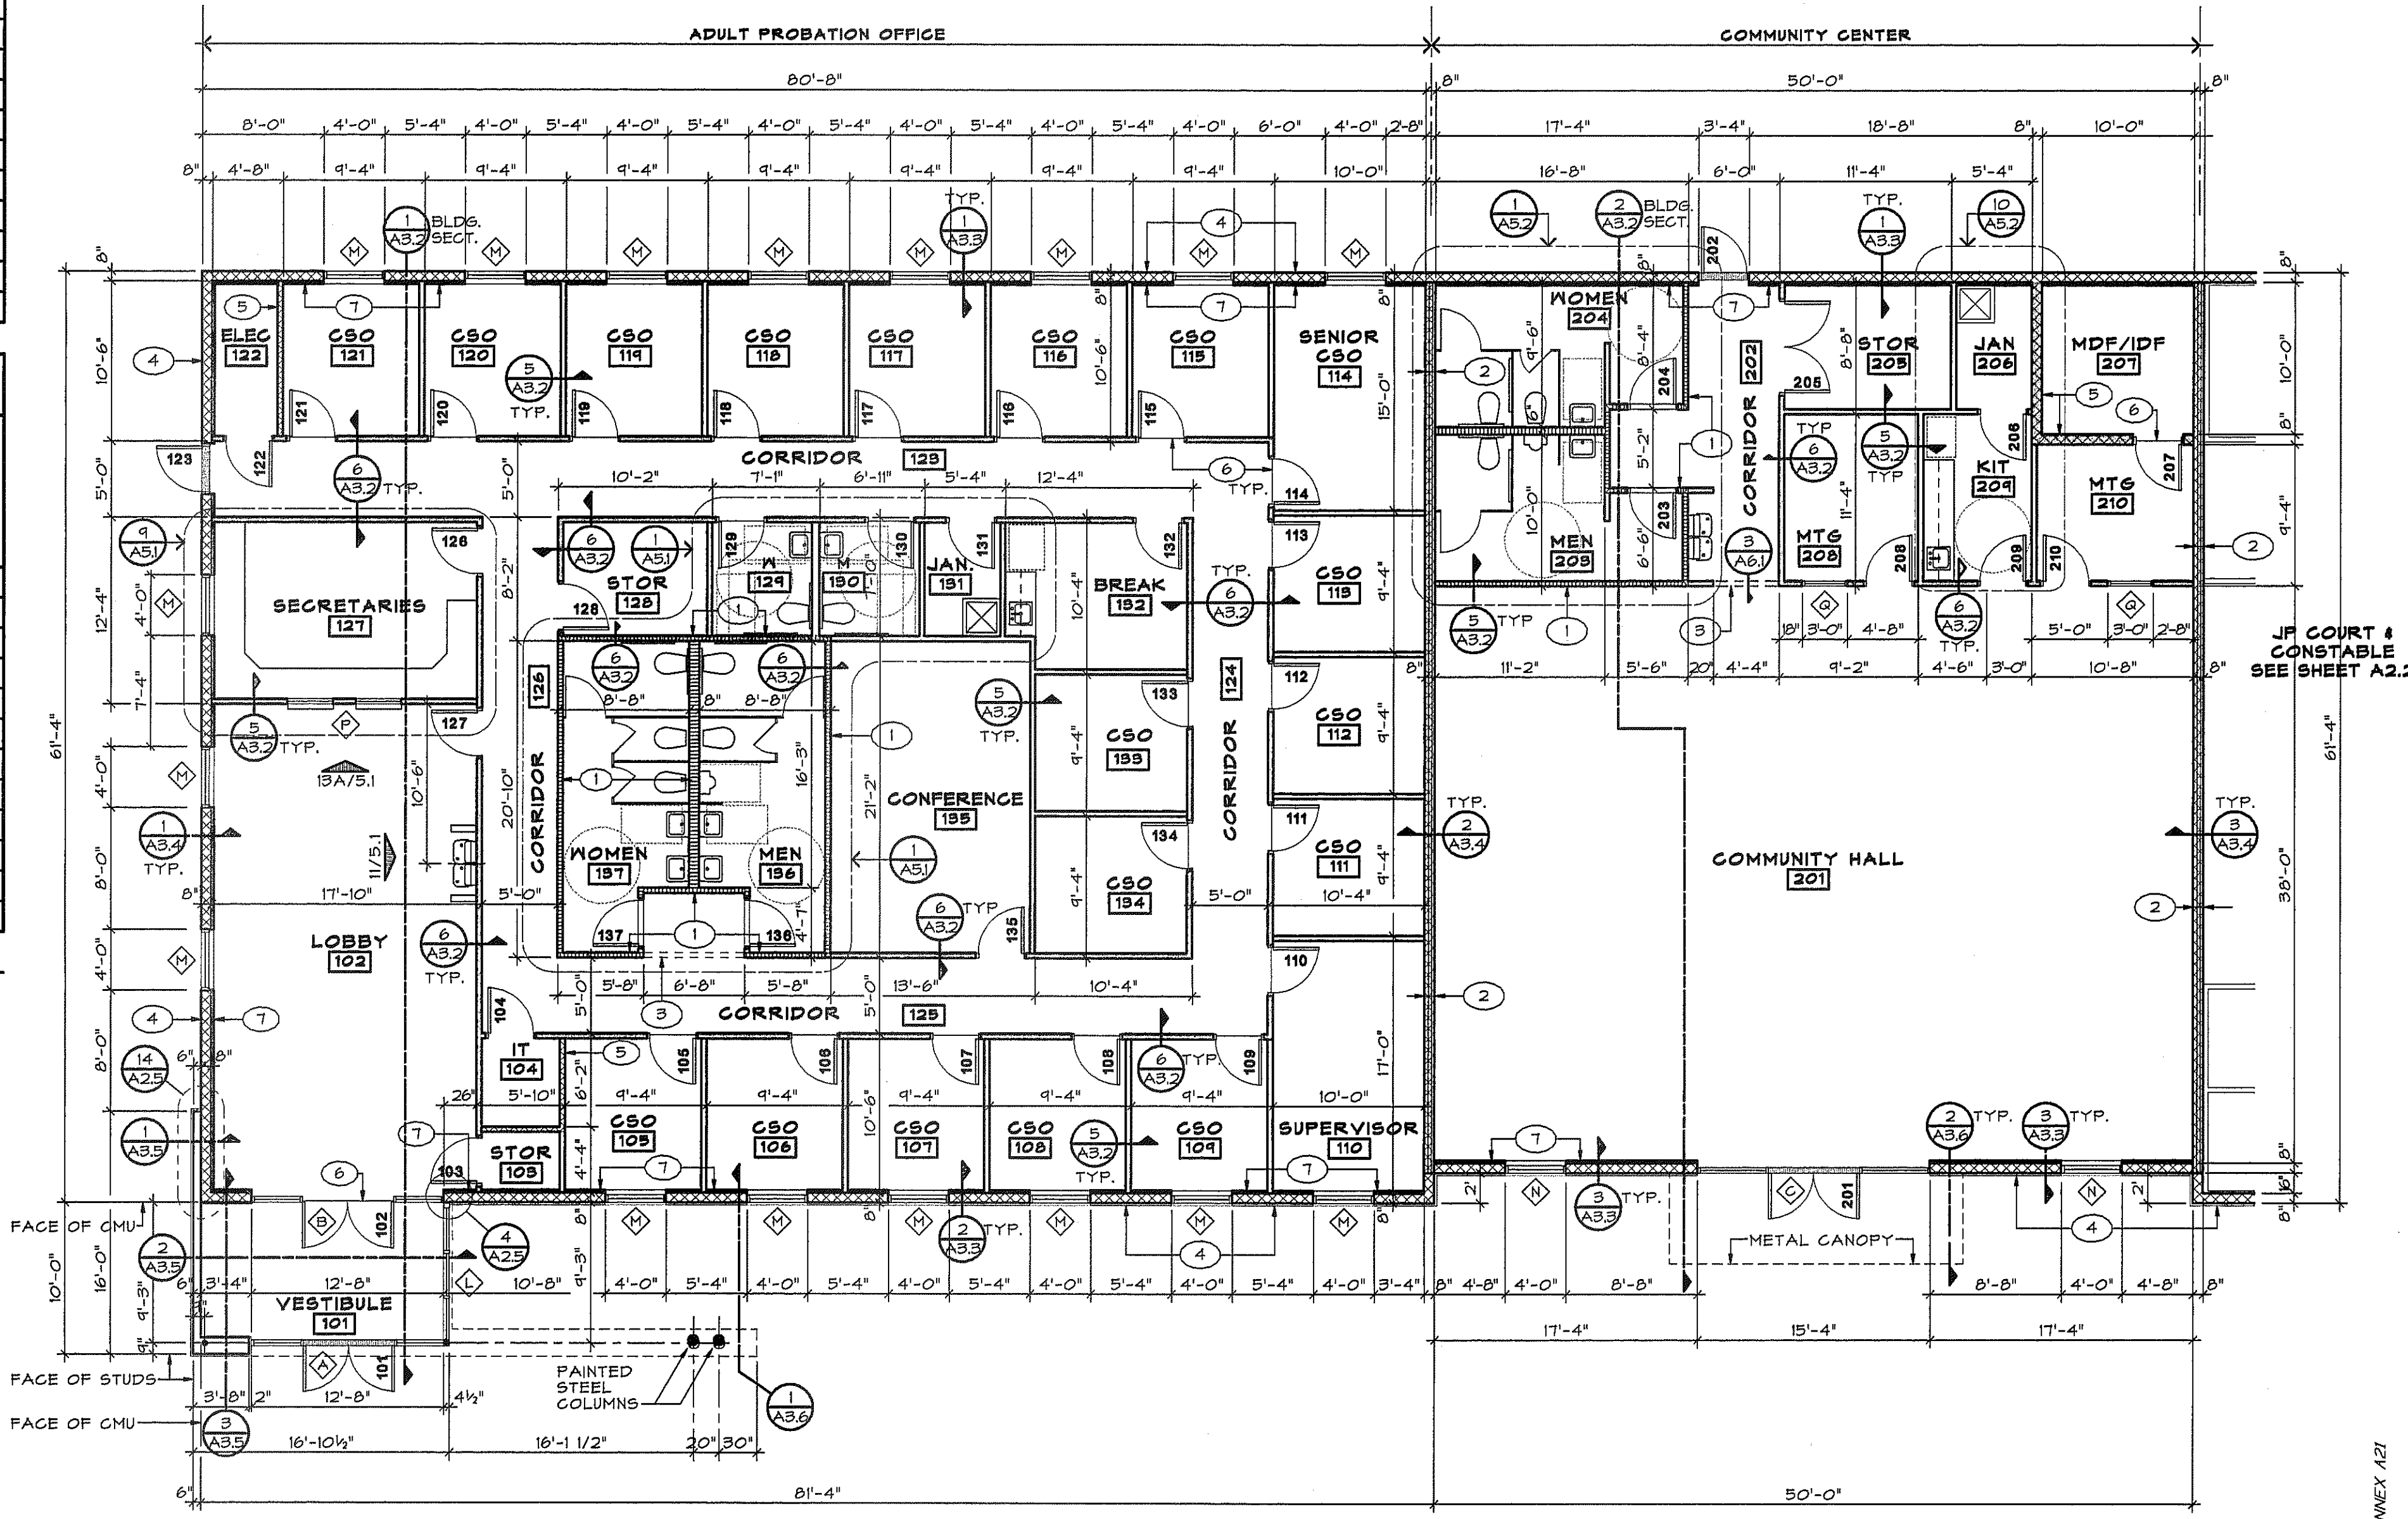

ADULT PROBATION OFFICE AND COMMUNITY CENTER

PARTIAL FLOOR PLAN - PART A

FLOOR PLAN LEGEND

----- TYPICAL NON-RATED STANDARD REINFORCED CMU (INTERIOR WALLS TO ABOVE CEILING)
===== TYPICAL 1 HR. REINFD. CMU - FIRESEAL TO DECK
===== TYPICAL 2 HR. REINFD. CMU - FIRESEAL TO DECK

===== TYPICAL NON-RATED STUD WALL CON

DOOR SCHEDULE															JP AND CONSTABLE				
MARK	DOOR					HARDWARE SECTION S10	FRAME						FIRE RATING	REMARKS					
	SIZE 1/4" THK. U.N.O.	TYPE	MAT'L.	FINISH	GLASS		TYPE	MAT'L.	FINISH	HEAD	JAMB	SILL							
301	3/0 x 7/0	I	AL	AN	TP	001	D1	AL	GA	1/A24	-	3/A24	-	1					
302	3/0 x 7/0	I	AL	AN	TP	001	D2	AL	GA	3/A24	-	3/A24	-	-					
303	3/0 x 7/0	II	SC	TF	-	012	6	HM	PTD	12/A24	3/A24	-	-	-					
304	3/0 x 7/0	II	SC	TF	-	012	6	HM	PTD	12/A24	3/A24	-	-	-					
305	3/0 x 7/0	III	SC	TF	TP	011	6	HM	PTD	12/A24	3/A24	-	-	-					
306	3/0 x 7/0	III	SC	TF	FR	011	6	HM	PTD	12/A24	3/A24	-	20 MIN	-					
306A	4/0 x 6/6	VI	STL	S.S.	-	015	MFR	S.S.	MFR	12/A24	3/A24	-	3/4 HR	-					
307	NOT USED																		
308	3/0 x 7/0	II	SC	TF	-	008	6	HM	PTD	12/A24	3/A24	-	20 MIN	-					
309	3/0 x 7/0	IV	HM	PTD	-	002	F	HM	PTD	1/A24	8/A24	1/A24	-	1 & 2					
310	3/0 x 7/0	II	SC	TF	-	004	6	HM	PTD	12/A24	3/A24	-	20 MIN	-					
311	3/0 x 7/0	II	SC	TF	-	004	6	HM	PTD	12/A24	3/A24	-	20 MIN	-					
312	NOT USED																		
313	3/0 x 7/0	II	SC	TF	-	004	6	HM	PTD	12/A24	3/A24	-	20 MIN	-					
314	3/0 x 7/0	II	SC	TF	-	004	6	HM	PTD	12/A24	3/A24	-	20 MIN	-					
315	3/0 x 7/0	II	SC	TF	-	012	6	HM	PTD	12/A24	3/A24	-	20 MIN	-					
316	3/0 x 7/0	II	SC	TF	-	012	6	HM	PTD	12/A24	3/A24	-	20 MIN	-					
317	3/0 x 7/0	II	SC	TF	-	008	6	HM	PTD	12/A24	3/A24	-	20 MIN	-					
318	3/0 x 7/0	II	SC	TF	-	012	6	HM	PTD	12/A24	3/A24	-	-	-					
319	3/0 x 7/0	II	SC	TF	FR	008	6	HM	PTD	12/A24	3/A24	-	20 MIN	-					
319A	3/0 x 7/0	II	SC	TF	-	008	6	HM	PTD	12/A24	3/A24	-	20 MIN	-					
319B	3/0 x 7/0	IV	HM	PTD	-	004	F	HM	PTD	1/A24	8/A24	1/A24	-	1 & 2					
320	3/0 x 7/0	III	SC	TF	FR	011	I	HM	PTD	-	-	-	20 MIN	-					
321	3/0 x 7/0	III	SC	TF	FR	016	6	HM	PTD	12/A24	3/A24	-	20 MIN	-					
322	3/0 x 7/0	II	SC	TF	-	011	6	HM	PTD	12/A24	3/A24	-	-	-					
323	3/0 x 7/0	III	SC	TF	FR	013	6	HM	PTD	12/A24	3/A24	-	-	-					
324	3/0 x 7/0	II	SC	TF	FR	012	6	HM	PTD	12/A24	3/A24	-	20 MIN	-					
325	3/0 x 7/0	IV	HM	PTD	-	008	F	HM	PTD	1/A24	8/A24	1/A24	-	1 & 2					
326	3/0 x 7/0	II	SC	TF	-	014	6	HM	PTD	12/A24	3/A24	-	-	-					


KEY	DESCRIPTION
F1	12X12 VINYL COMPOSITION TILE (VCT)
F2	CARPET TILES
F3	12X12 PORCELAIN CERAMIC TILE
F4	PORCELAIN CERAMIC MOSAIC TILE
F5	CLEAN EXPOSED CONCRETE - FINISH WITH SEALER ONLY
F6	EPOXY FLOOR COATING
B1	4" VINYL BASE
B2	PORCELAIN CERAMIC STRAIGHT BASE
B3	PORCELAIN CMT COVE BASE
B4	NO BASE
B5	OAK BASE
W1	PAINTED GYP. BD. - TAPE, BED, TEXTURE, PRIME & PAINT
W2	PORCELAIN CERAMIC WALL TILE
W3	PAINTED CMU - BLOCK FILLER, PRIMER & PAINT
G1	2' x 4' LAY-IN MINERAL PANELS WITH SPECIFIED GRID
G2	2' x 2' LAY-IN TEGULAR EDGE PANELS WITH SPECIFIED GRID
G3	2' x 2' CHROME GRID W/ ACRYLIC PARABOLIC CHROME LENS PANELS
C2	PAINTED GYP. BD. - TAPE, BED, TEXTURE, PRIME & PAINT
C3	CLEAN ALL STRUCTURAL ELEMENTS - NO FINISH REQUIRED
C4	CLEAN EXPOSED CONCRETE - PAINT FINISH



ROOM FINISH SCHEDULE										JP AND CONSTABLE	
NO.	ROOM NAME	FLOOR	BASE	WALLS				CEILINGS	CLG. HGT.	REMARKS	
				N	E	S	W				
301	VESTIBULE	F3	B2	W1	W1	W1	W1	C1	10'-0"		
302	LOBBY	F1	B1	W1	W1	W1	W1	C1	9'-0"	3	
303	MEN	F4	B3	W1	W1	W1	W1	C2	8'-0"	1	
304	WOMEN	F4	B3	W1	W1	W1	W1	C2	8'-0"	1	
305	CORRIDOR	F1	B1	W1	W1	W1	W1	C1	9'-0"		
306	OPEN OFFICE	F2	B1	W1	W1	W1	W1	C1	9'-0"		
307	NOT USED	-	-	-	-	-	-	-	-		
308	OFFICE	F2	B1	W1	W1	W1	W1	C1	9'-0"		
309	BREAK ROOM	F1	B1	W1	W1	W1	W1	C1	9'-0"		
310	JANITOR	F1	B1	W1	W1	W1	W1	C1	8'-0"	2	
311	STORAGE	F1	B1	W1	W1	W1	W1	C1	9'-0"		
312	CORRIDOR	F2	B1	W1	W1	W1	W1	C1	9'-0"		
313	IT	F1	B1	W1	W1	W1	W1	C3	-		
314	ELECTRICAL	F1	B1	W1	W1	W1	W1	C3	-		
315	WOMEN	F4	B3	W1	W1	W1	W1	C2	8'-0"	1	
316	MEN	F4	B3	W1	W1	W1	W1	C2	8'-0"	1	
317	OFFICE	F2	B1	W1	W1	W1	W1	C1	9'-0"		
318	TOILET	F3	B2	W1	W1	W1	W2	C2	8'-0"	1 & 4	
319	JUDGE	F2	B1	W1	W1	W1	W1	C1	9'-0"		
320	PUBLIC	F2	B5	W1	W1	W1	W1	C1	9'-0"	5	
321	COURTROOM	F2	B5	W1	W1	W1	W1	C1	VARIES	5	
322	JURY ROOM	F1	B1	W1	W1	W1	W1	C1	9'-0"		
323	TOILET	F4	B3	W1	W1	W1	W1	C2	8'-0"		
324	DEPUTIES	F1	B1	W1	W1	W1	W1	C1	9'-0"		
325	DEPUTIES	F1	B1	W1	W1	W1	W1	C1	9'-0"		
326	CONSTABLE	F2	B1	W1	W1	W1	W1	C1	9'-0"		

REMARKS
1. PROVIDE WATER-RESISTANT GYP. BD. AT ALL PLUMBING WALLS.
2. PROVIDE 48" HIGH FRP MAINSCOT - 36" EACH WAY FROM CORNER AT MOP SINK - FULL TRIM AT PERIMETER OF FRP - SEE INTERIOR ELEVATIONS
3. PROVIDE 1/2" TILE ON WALL BEHIND ENCL. - BULLNOSE ALL AROUND - SEE ELEVATIONS
4. NO BASE AT TILED WALLS
5. SEE REFLECTED CEILING PLAN SHT. A6.2 FOR COURTROOM & PUBLIC CEILING CONSTRUCTION
6. PROVIDE 1/2" TILE ON 5 WALLS AT ENG ALCOVE - BULLNOSE ALL AROUND - SEE ELEVATIONS

DOOR SCHEDULE													SHERIFF'S SUBSTATION												
MARK	DOOR					HARDWARE SECTION S10	FRAME						FIRE RATING	REMARKS											
	SIZE 1/4" THK. UNO.	TYPE	MAT'L.	FINISH	GLASS		TYPE	MAT'L.	FINISH	HEAD	JAMB	SILL													
401	3/0 x 7/0	I	AL	AN	TP	001	E	AL	CA	10/A24	-	3/A24	-	1											
402	3/0 x 7/0	II	SC	TF	-	004	6	HM	PTD	12/A24	B/A24	-	20 MIN	-											
403	3/0 x 7/0	II	SC	TF	-	012	6	HM	PTD	12/A24	B/A24	-	20 MIN	-											
404	3/0 x 7/0	II	SC	TF	-	004	6	HM	PTD	12/A24	B/A24	-	20 MIN	-											
405	3/0 x 7/0	II	SC	TF	-	008	J	HM	PTD	-	-	-	20 MIN	-											
406	3/0 x 7/0	III	SC	TF	TP	011	6	HM	PTD	12/A24	B/A24	-	-	-											
407	3/0 x 7/0	II	SC	TF	-	004	6	HM	PTD	12/A24	B/A24	-	-	-											
408	3/0 x 7/0	II	SC	TF	-	004	6	HM	PTD	12/A24	B/A24	-	-	-											
409	3/0 x 7/0	III	SC	TF	FR	017	6	HM	PTD	12/A24	B/A24	-	20 MIN	-											
409A	3/0 x 7/0	IV	HM	PTD	-	011	F	HM	PTD	14/A24	B/A24	-	90 MIN	-											
410	3/0 x 7/0	III	SC	TF	FR	013	6	HM	PTD	12/A24	B/A24	-	20 MIN	-											
411	3/0 x 7/0	II	SC	TF	-	004	6	HM	PTD	12/A24	B/A24	-	-	-											
412	3/0 x 7/0	II	SC	TF	-	010	6	HM	PTD	12/A24	B/A24	-	20 MIN	-											
413	3/0 x 7/0	II	SC	TF	-	010	6	HM	PTD	12/A24	B/A24	-	20 MIN	-											
414	3/0 x 7/0	IV	HM	PTD	-	005	F	HM	PTD	17A24	8/A24	1/A24	-	-											
415	3/0 x 7/0	II	SC	TF	-	010	6	HM	PTD	12/A24	B/A24	-	-	-											
416	3/0 x 7/0	II	SC	TF	-	010	6	HM	PTD	12/A24	B/A24	-	-	-											
417	3/0 x 7/0	II	SC	TF	-	004	6	HM	PTD	12/A24	B/A24	-	-	-											
418	3/0 x 7/0	III	SC	TF	FR	018	F	HM	PTD	14/A24	B/A24	-	20 MIN	-											
418A	3/0 x 7/0	IV	HM	PTD	-	006	F	HM	PTD	17A24	8/A24	1/A24	-	1 & 2											
419	3/0 x 7/0 x 2'	V	STL	PTD	-	007	MFR	STL	PTD	-	-	-	-	-											
420	3/0 x 7/0 x 2'	V	STL	PTD	-	007	MFR	STL	PTD	-	-	-	-	-											
421	3/0 x 7/0 x 2'	V	STL	PTD	-	007	MFR	STL	PTD	-	-	-	-	-											
422	3/0 x 7/0 x 2'	V	STL	PTD	-	007	MFR	STL	PTD	-	-	-	-	-											
423	3/0 x 7/0	IV	HM	PTD	-	006	F	HM	PTD	17A24	8/A24	1/A24	-	1 & 2											
424	3/0 x 7/0	III	SC	TF	FR	011	6	HM	PTD	12/A24	B/A24	-	20 MIN	-											
424A	3/0 x 7/0	II	SC	TF	-	018	F	HM	PTD	14/A24	B/A24	-	-	-											
424B	3/0 x 7/0	II	SC	TF	-	018	F	HM	PTD	14/A24	B/A24	-	-	-											
425	3/0 x 7/0	III	SC	TF	TP	011	F	HM	PTD	14/A24	B/A24	-	-	-											
426	3/0 x 7/0	II	SC	TF	-	004	6	HM	PTD	12/A24	B/A24	-	20 MIN	-											
427	3/0 x 7/0	III	SC	TF	FR	011	6	HM	PTD	12/A24	B/A24	-	20 MIN	-											
427A	3/0 x 7/0	III	SC	TF	FR	018	F	HM	PTD	14/A24	B/A24	-	20 MIN	-											
428	3/0 x 7/0	III	SC	TF	FR	008	6	HM	PTD	12/A24	B/A24	-	20 MIN	-											
429	3/0 x 7/0	III	SC	TF	FR	008	6	HM	PTD	12/A24	B/A24	-	20 MIN	-											
430	3/0 x 7/0	III	SC	TF	FR	008	6	HM	PTD	12/A24	B/A24	-	20 MIN	-											

REMARKS
1. SEE DETAIL 1/A2.0 FOR REQUIRED MANEUVERING CLEARANCES AT EXTERIOR DOORS.
2. USE DOOR SCOPE AT THIS DOOR - DUSEUNG DS1000 M6-6REY

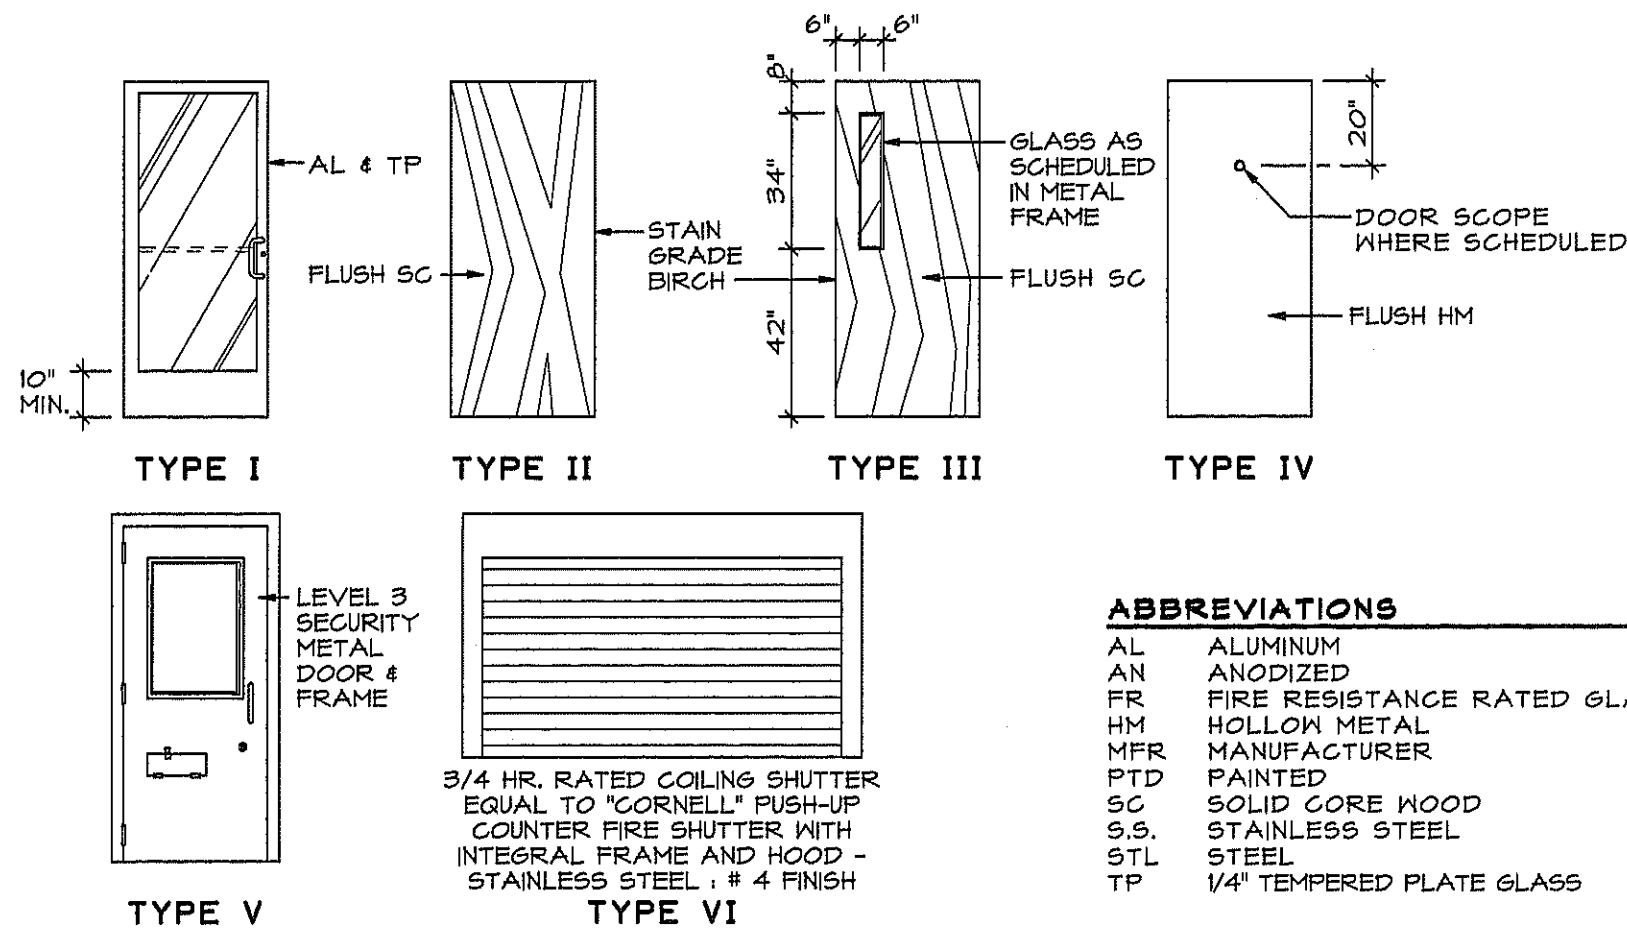

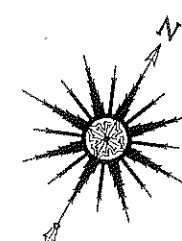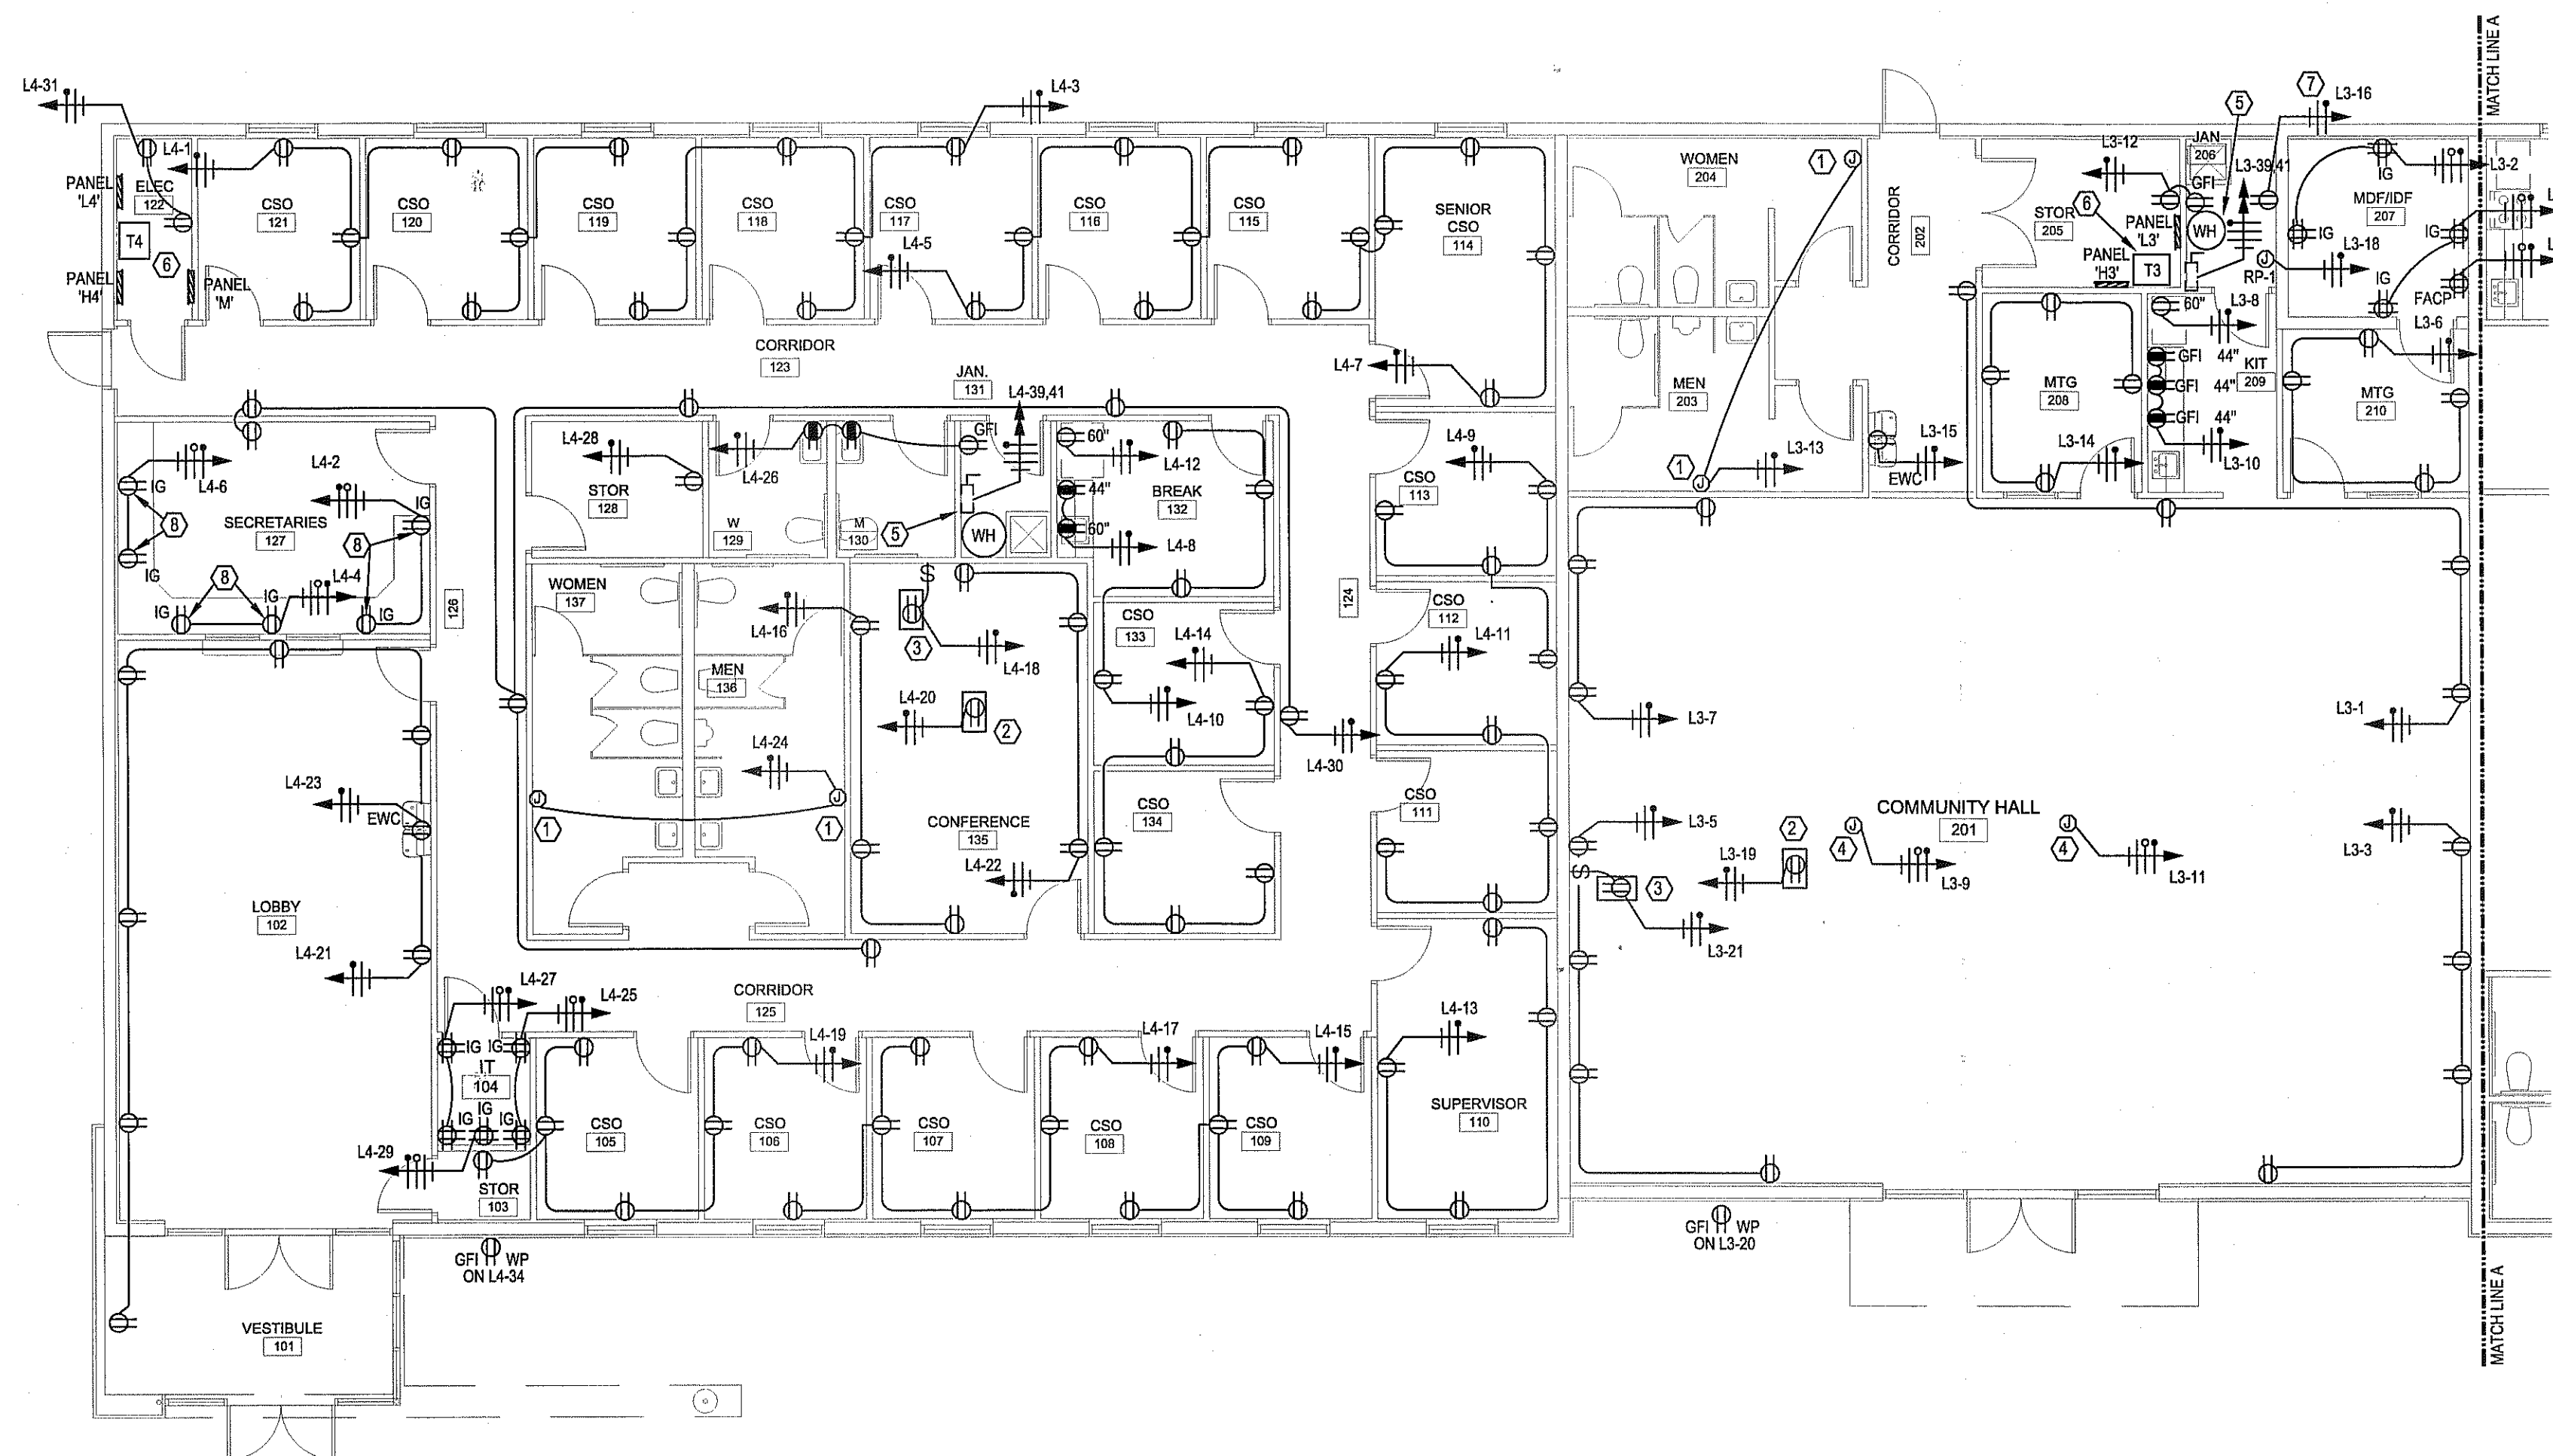

PARTIAL POWER PLAN

SCALE: 1/8" = 1'-0"

ADULT PROBATION & COMMUNITY CENTER

POWER PLAN KEYED NOTES


- ① INSTALL J-BOX AT 44" ABOVE FINISH FLOOR FOR HAND DRYER, MAKE ALL FINAL CONNECTIONS PER MANUFACTURER RECOMMENDATION.
- ② INSTALL RECEPTACLE ON CEILING FOR PROJECTOR, REFER TO DETAIL 3/E-11.
- ③ INSTALL RECEPTACLE ON CEILING FOR SCREEN PROJECT, REFER TO DETAIL 3/E-11.
- ④ J BOX ON CEILING WITH COVER FOR FUTURE POWER POLE.
- ⑤ INSTALL 40A, 2 POLE, NON-FUSED DISCONNECT, MAKE CONNECTIONS TO WATER HEATER AS REQUIRED.
- ⑥ INSTALL TRANSFORMER WITH ISOLATORS PER MANUFACTURERS RECOMMENDATIONS.
- ⑦ OUTLET AT 48" AFF FOR IRRIGATION CONTROLLER, J-BOX 1" WITH PULLSTRING FOR LOW VOLTAGE WIRING BY OTHERS.
- ⑧ INSTALL RECEPTACLES ABOVE COUNTER, COORDINATE WITH ARCHITECTURAL PLANS BEFORE DOING ANY WORK.

REVISIONS

- 1
- 2
- 3
- 4

DRAWN BY: STAFF
CHECKED BY: STAFF
DATE: DEC. 2012
PROJ. NO.: 9.0307

PARTIAL POWER
PLAN

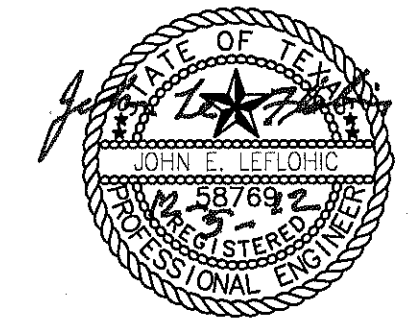



NORTHWEST ANNEX
FOR
THE COUNTY OF EL PASO
435 VINTON ROAD VINTON, TEXAS

REVISIONS	
1	
2	
3	
4	

DRAWN BY: STAFF
CHECKED BY: STAFF
DATE: DEC. 2012
PROJ. NO.: 9.0307

PARTIAL POWER
PLAN

E-6

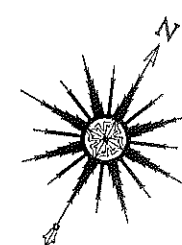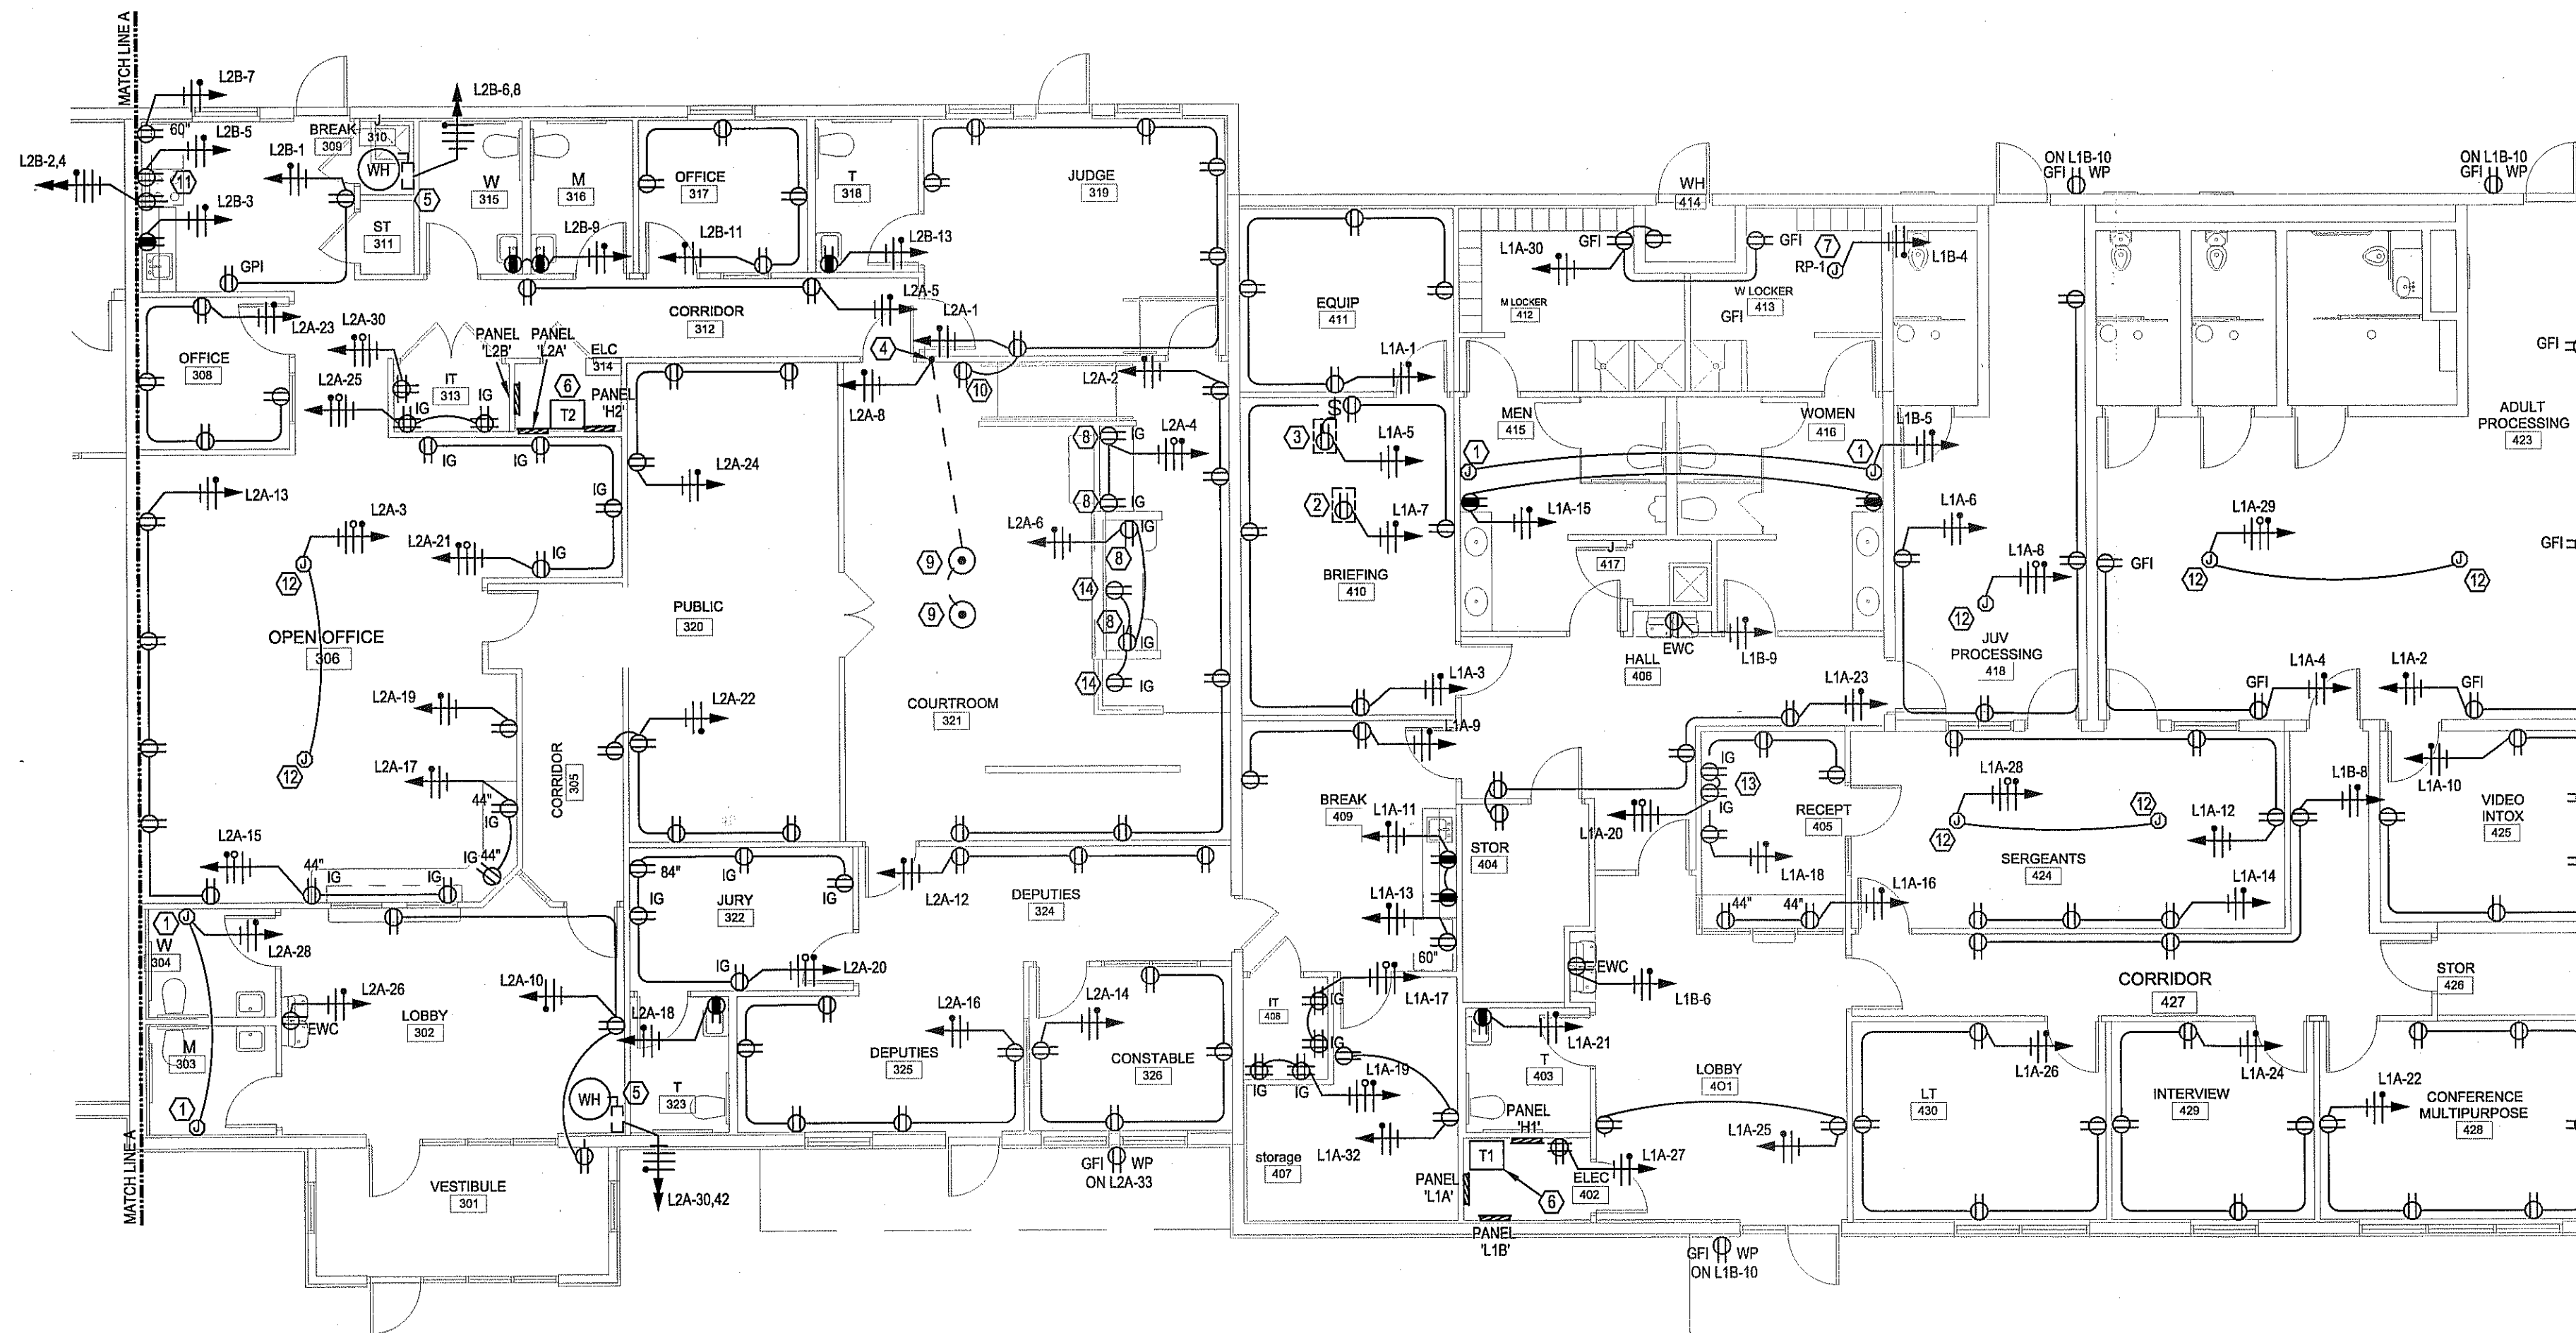

PARTIAL POWER PLAN

SCALE: 1/8" = 1'-0"

JUSTICE OF PEACE & SHERIFF



POWER PLAN KEYED NOTES

1. INSTALL J-BOX AT 4" ABOVE FINISH FLOOR FOR HAND DRYER, MAKE ALL FINAL CONNECTIONS PER MANUFACTURER RECOMMENDATION.
2. INSTALL RECEPTACLE ON CEILING FOR PROJECTOR, REFER TO DETAIL 3/E-11.
3. INSTALL RECEPTACLE ON CEILING FOR SCREEN PROJECT, REFER TO DETAIL 3/E-11.
4. STUBB UP 3/4" CONDUIT TO CIRCUIT AS SHOWN.
5. INSTALL 40A, 2 POLE, NON-FUSED DISCONNECT, MAKE CONNECTIONS TO WATER HEATER AS REQUIRED.
6. INSTALL TRANSFORMER WITH ISOLATORS PER MANUFACTURERS RECOMMENDATIONS.
7. INSTALL J-BOX NEAR TO CIRCULATING PUMP, MAKE CONNECTIONS TO CP-1 AS REQUIRED.
8. INSTALL ISOLATED GROUND (IG) RECEPTACLE UNDER COUNTER, COORDINATE WITH CABINET WORK INSTALLER BEFORE DOING ANY WORK.
9. INSTALL FLOOR MOUNTED BOX WITH POWER RECEPTACLE, PHONE/DATA RECEPTACLE AND MICROPHONE JACK. COORDINATE WITH OWNER FOR EXACT LOCATION.
10. INSTALL RECEPTACLE IN GYP. BOARD SOFFIT FOR TELEVISION, COORDINATE WITH OWNER FOR EXACT LOCATION BEFORE DOING ANY WORK.
11. RECEPTACLE FOR RANGE HOOD, COORDINATE WITH EQUIPMENT INSTALLER BEFORE DOING ANY WORK.
12. INSTALL CEILING MOUNTED J-BOX WITH COVER FOR FUTURE POWER POLES, COORDINATE WITH OWNER FOR EXACT LOCATION.
13. LOCATE RECEPTACLE FOR TV PROJECTOR AT 84" AFF, COORDINATE WITH OWNER FOR EXACT HEIGHT AND LOCATION.
14. INSTALL RECEPTACLE IN WALL ABOVE COUNTER, COORDINATE WITH ARCHITECTURAL DRAWINGS FOR EXACT LOCATION.



SPECIAL SYSTEMS KEYED NOTES

1. INSTALL J-BOX AT 96" AFF CEILING FOR CAMERA. INSTALL 3/4" CONDUIT WITH PULLSTRING TO CABLE TRAY. COORDINATE EXACT LOCATION WITH OWNER BEFORE DOING ANY WORK.
2. INSTALL 5/8" FIRE TREATED PLYWOOD, COMPLETELY ON ALL FOUR WALLS OF IT ROOM OR MDF/IDF ROOM.
3. INSTALL (2) 4" CONDUIT WITH (4) PULLSTRING ON EACH CONDUIT, USE LONG 36" LONG SWEEPS RADIUS ELLS ON ALL TURNS.
4. INSTALL (3) 4" CONDUIT WITH (4) PULLSTRING ON EACH CONDUIT, USE LONG 36" LONG SWEEPS RADIUS ELLS ON ALL TURNS.
5. INSTALL CEILING MOUNTED 4" SQ. DEEP J-BOX FOR FUTURE POWER POLE. INSTALL 1" CONDUIT WITH PULLSTRING CABLE TRAY COORDINATE WITH OWNER FOR EXACT LOCATION.
6. INSTALL J-BOX AT 96" ABOVE FINISH GRADE FOR CAMERA. INSTALL 3/4" CONDUIT TO CABLE TRAY. COORDINATE EXACT LOCATION WITH OWNER BEFORE DOING ANY WORK.
7. INSTALL 4" SQ. DEEP J-BOX WITH COVER AT CEILING FOR PROJECTOR/COMPUTER INTERCONNECTION. COORDINATE WITH OWNER FOR EXACT LOCATION.
8. INSTALL 4" SQ. DEEP J-BOX WITH COVER AT 18" AFF FOR PROJECTOR/COMPUTER INTERCONNECTIONS. COORDINATE WITH OWNER FOR EXACT LOCATION.
9. INSTALL 3/4" CONDUIT WITH PULLSTRING.
10. INSTALL WEATHER PROOF 4" SQUARE J-BOX WITH WEATHER PROOF COVER AT 12" ABOVE FINISH GRADE FOR CAMERA. INSTALL 3/4" CONDUIT WITH PULLSTRING TO NEAREST CABLE TRAY. COORDINATE WITH OWNER FOR EXACT LOCATION. WATER PROOF AND FIRE PROOF ALL PENETRATIONS INTO BUILDING.
11. INSTALL 1" CONDUIT WITH PULLSTRING TO IRRIGATION CONTROL BOX. COORDINATE WITH IRRIGATION CONTROLLER BEFORE DOING ANY WORK.
12. INSTALL 4" CONDUIT WITH (4) PULLSTRINGS, USE LONG RADIUS 36" ELLS ON ALL TURNS. REFER TO ELECTRICAL SITE PLAN FOR CONTINUATION.
13. INSTALL WEATHER PROOF 4" SQ. DEEP J-BOX FOR KEYCARD LOCK. COORDINATE WITH OWNER BEFORE DOING ANY WORK. INSTALL 1" CONDUIT TO NEAREST CABLE TRAY.
14. INSTALL 4" SQ. J-BOX ABOVE DOOR FOR CONTROLS.

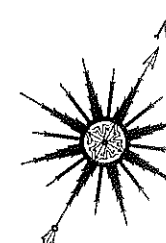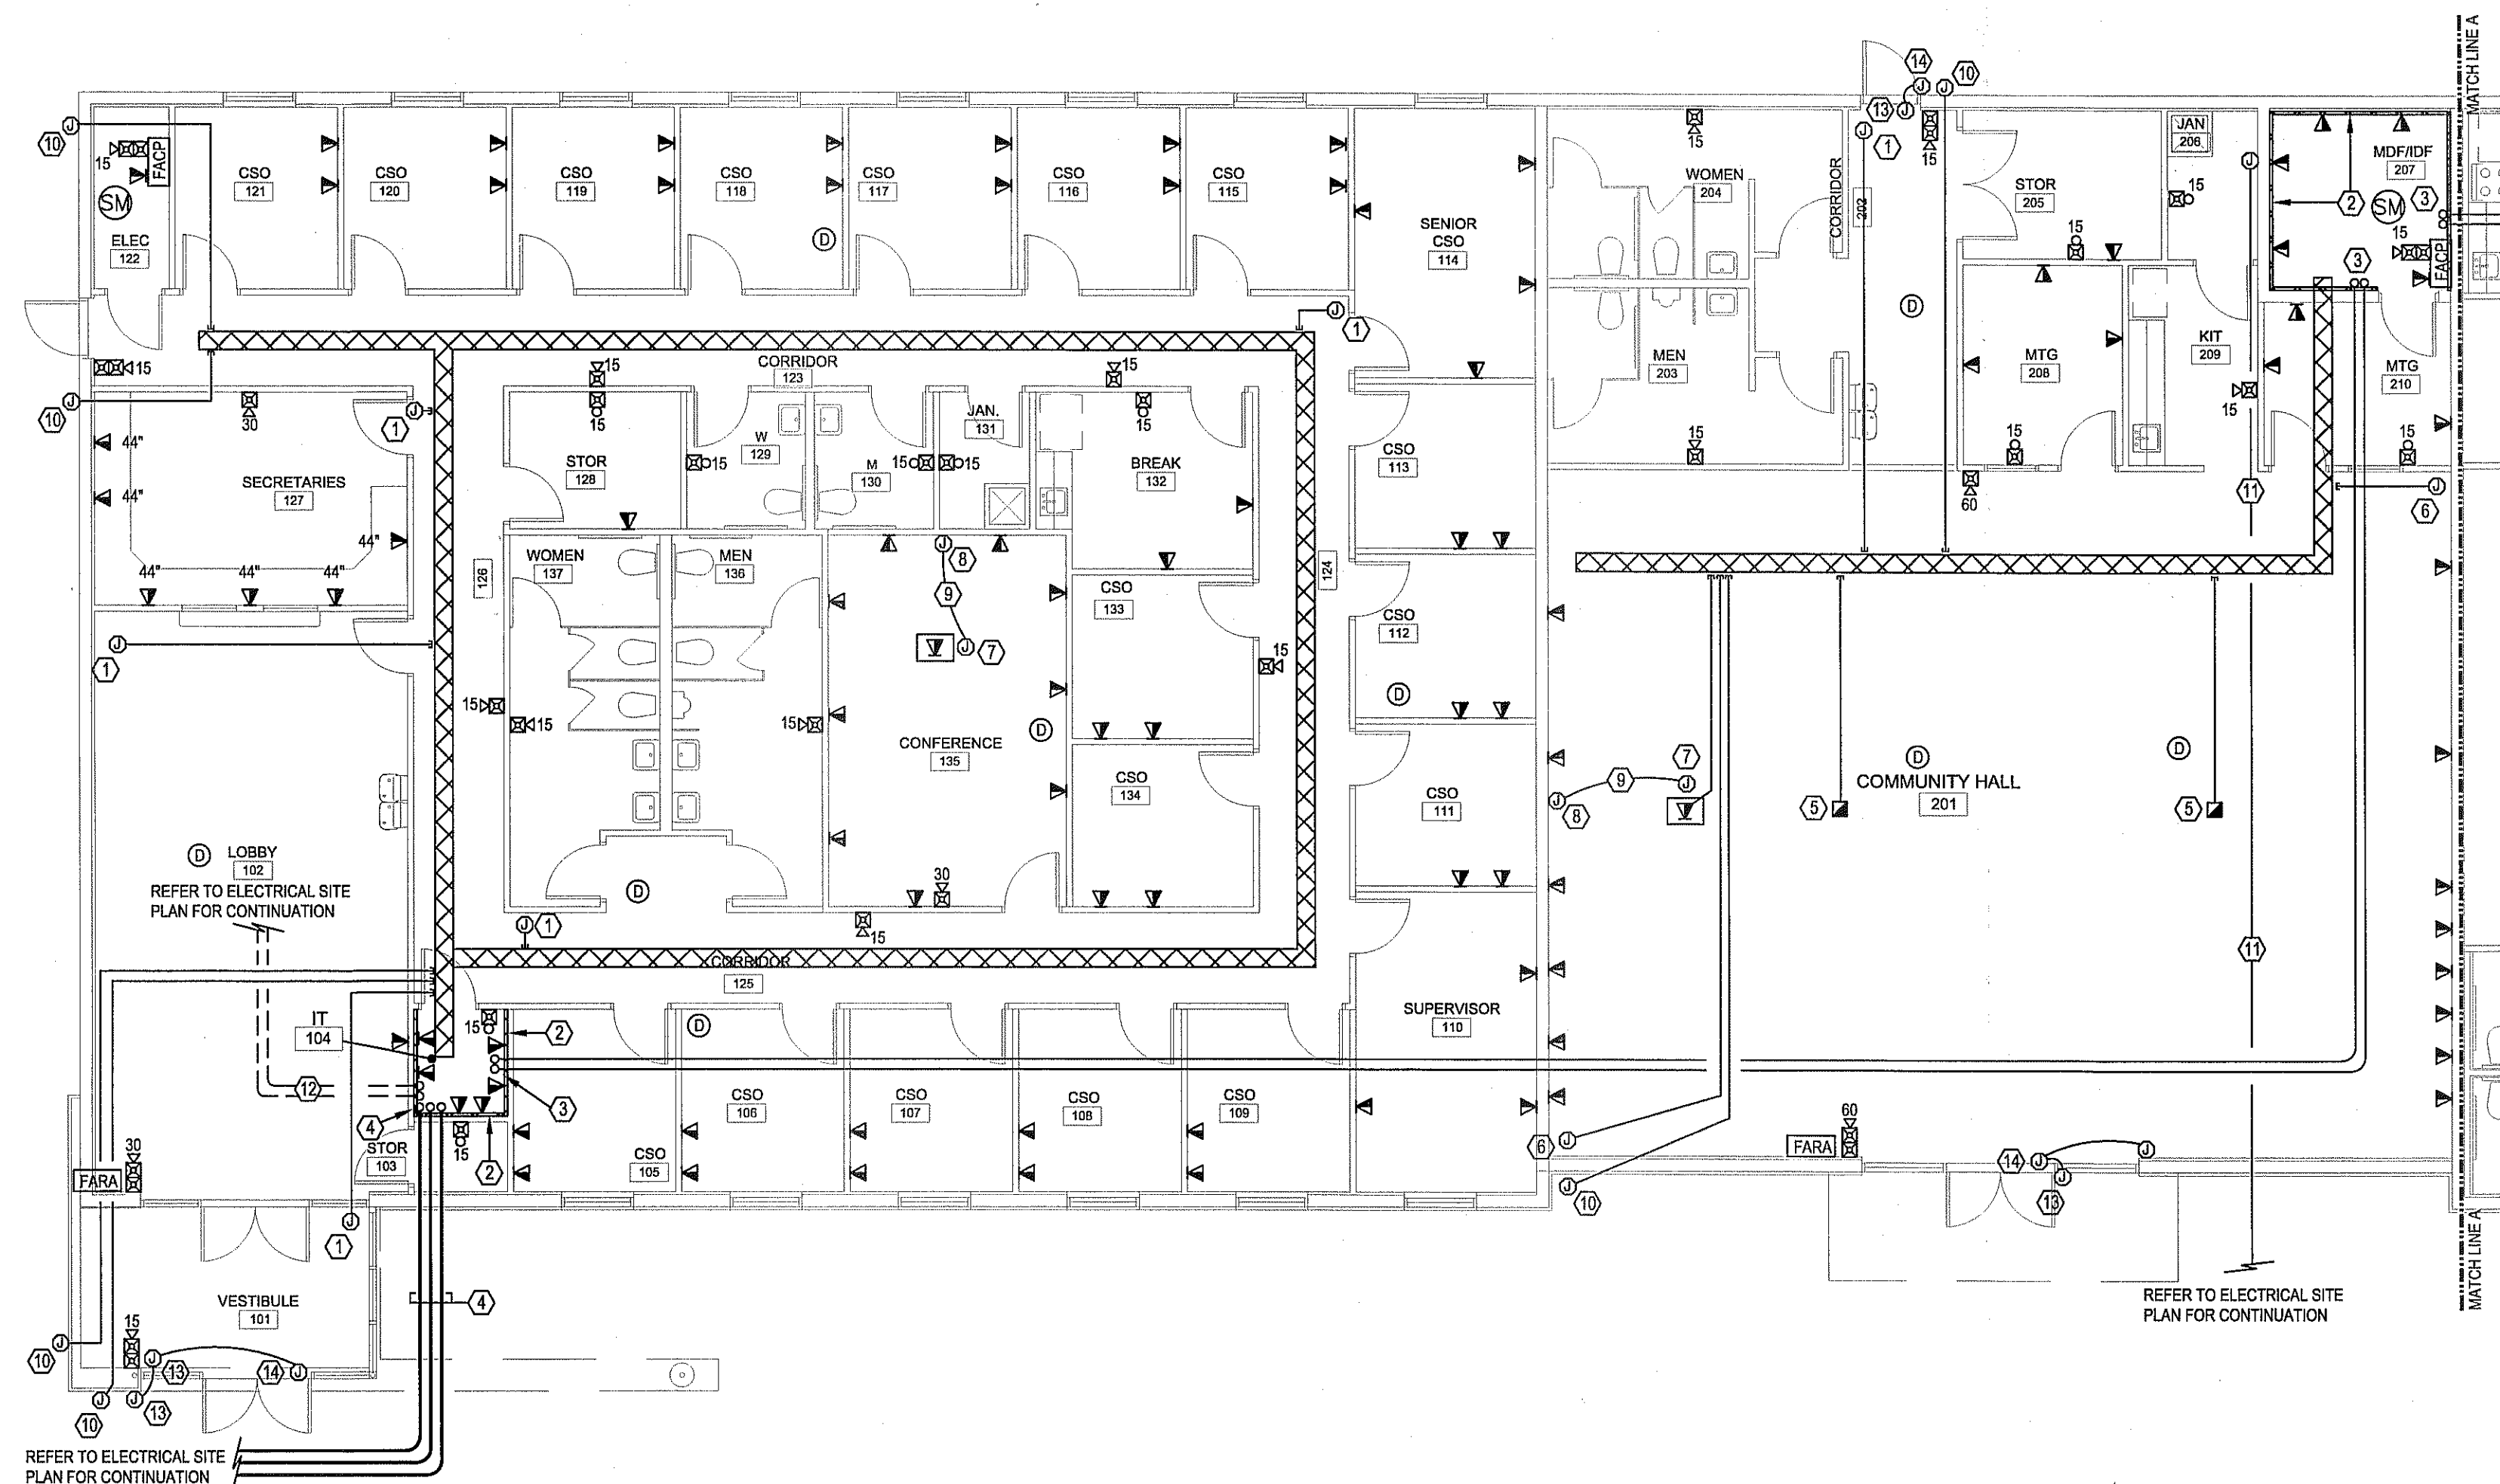


SPECIAL SYSTEMS PLAN

SCALE: 1/8" = 1'-0"

ADULT PROBATION & COMMUNITY CENTER

LEGEND

12" WIRE MESH CABLE TRAY

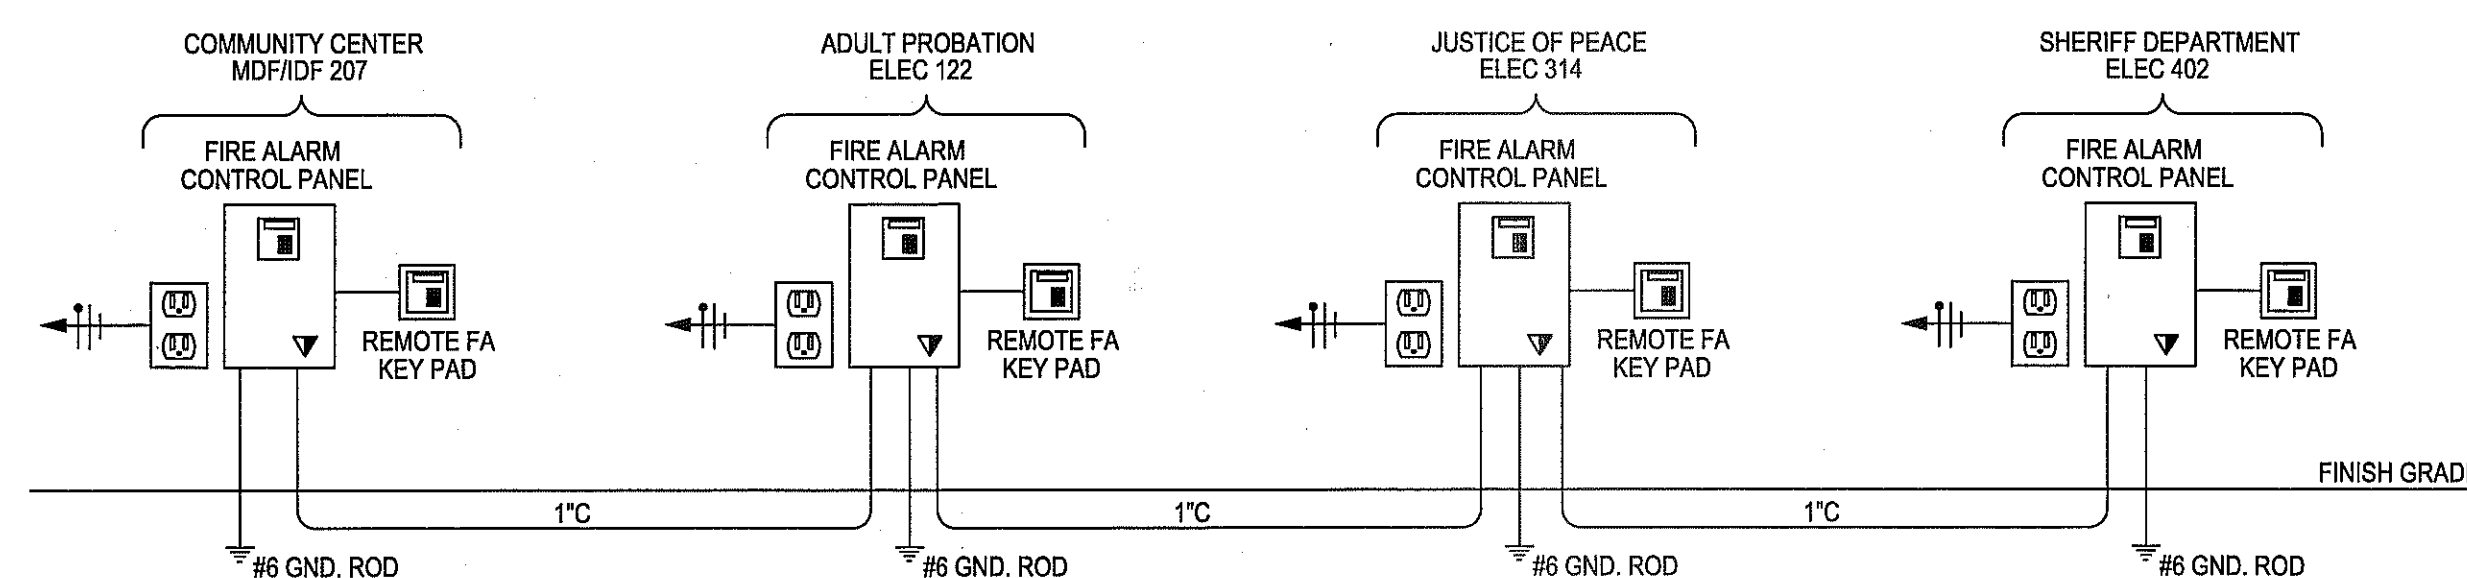

1 FIRE ALARM RISER DIAGRAM


E-7

NTS

2 CABLE TRAY DETAIL

E-7

NTS

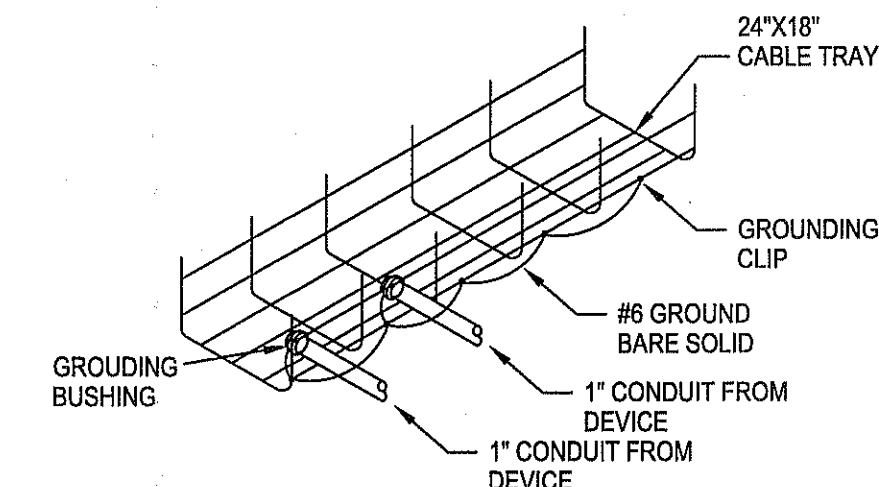


REVISIONS



DRAWN BY: STAFF
CHECKED BY: STAFF
DATE: DEC. 2012
PROJ. NO.: 9.0307



PARTIAL SPECIAL
SYSTEM PLAN

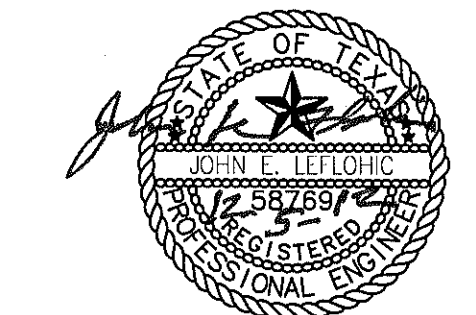

STATE OF TEXAS
COUNTY OF EL PASO
JAN 25 2013
RECORDED

WITNESSED BY
NOTARY PUBLIC
JAN 25 2013

NORTHWEST ANNEX
FOR
THE COUNTY OF EL PASO
435 VINTON ROAD VINTON, TEXAS

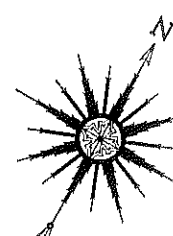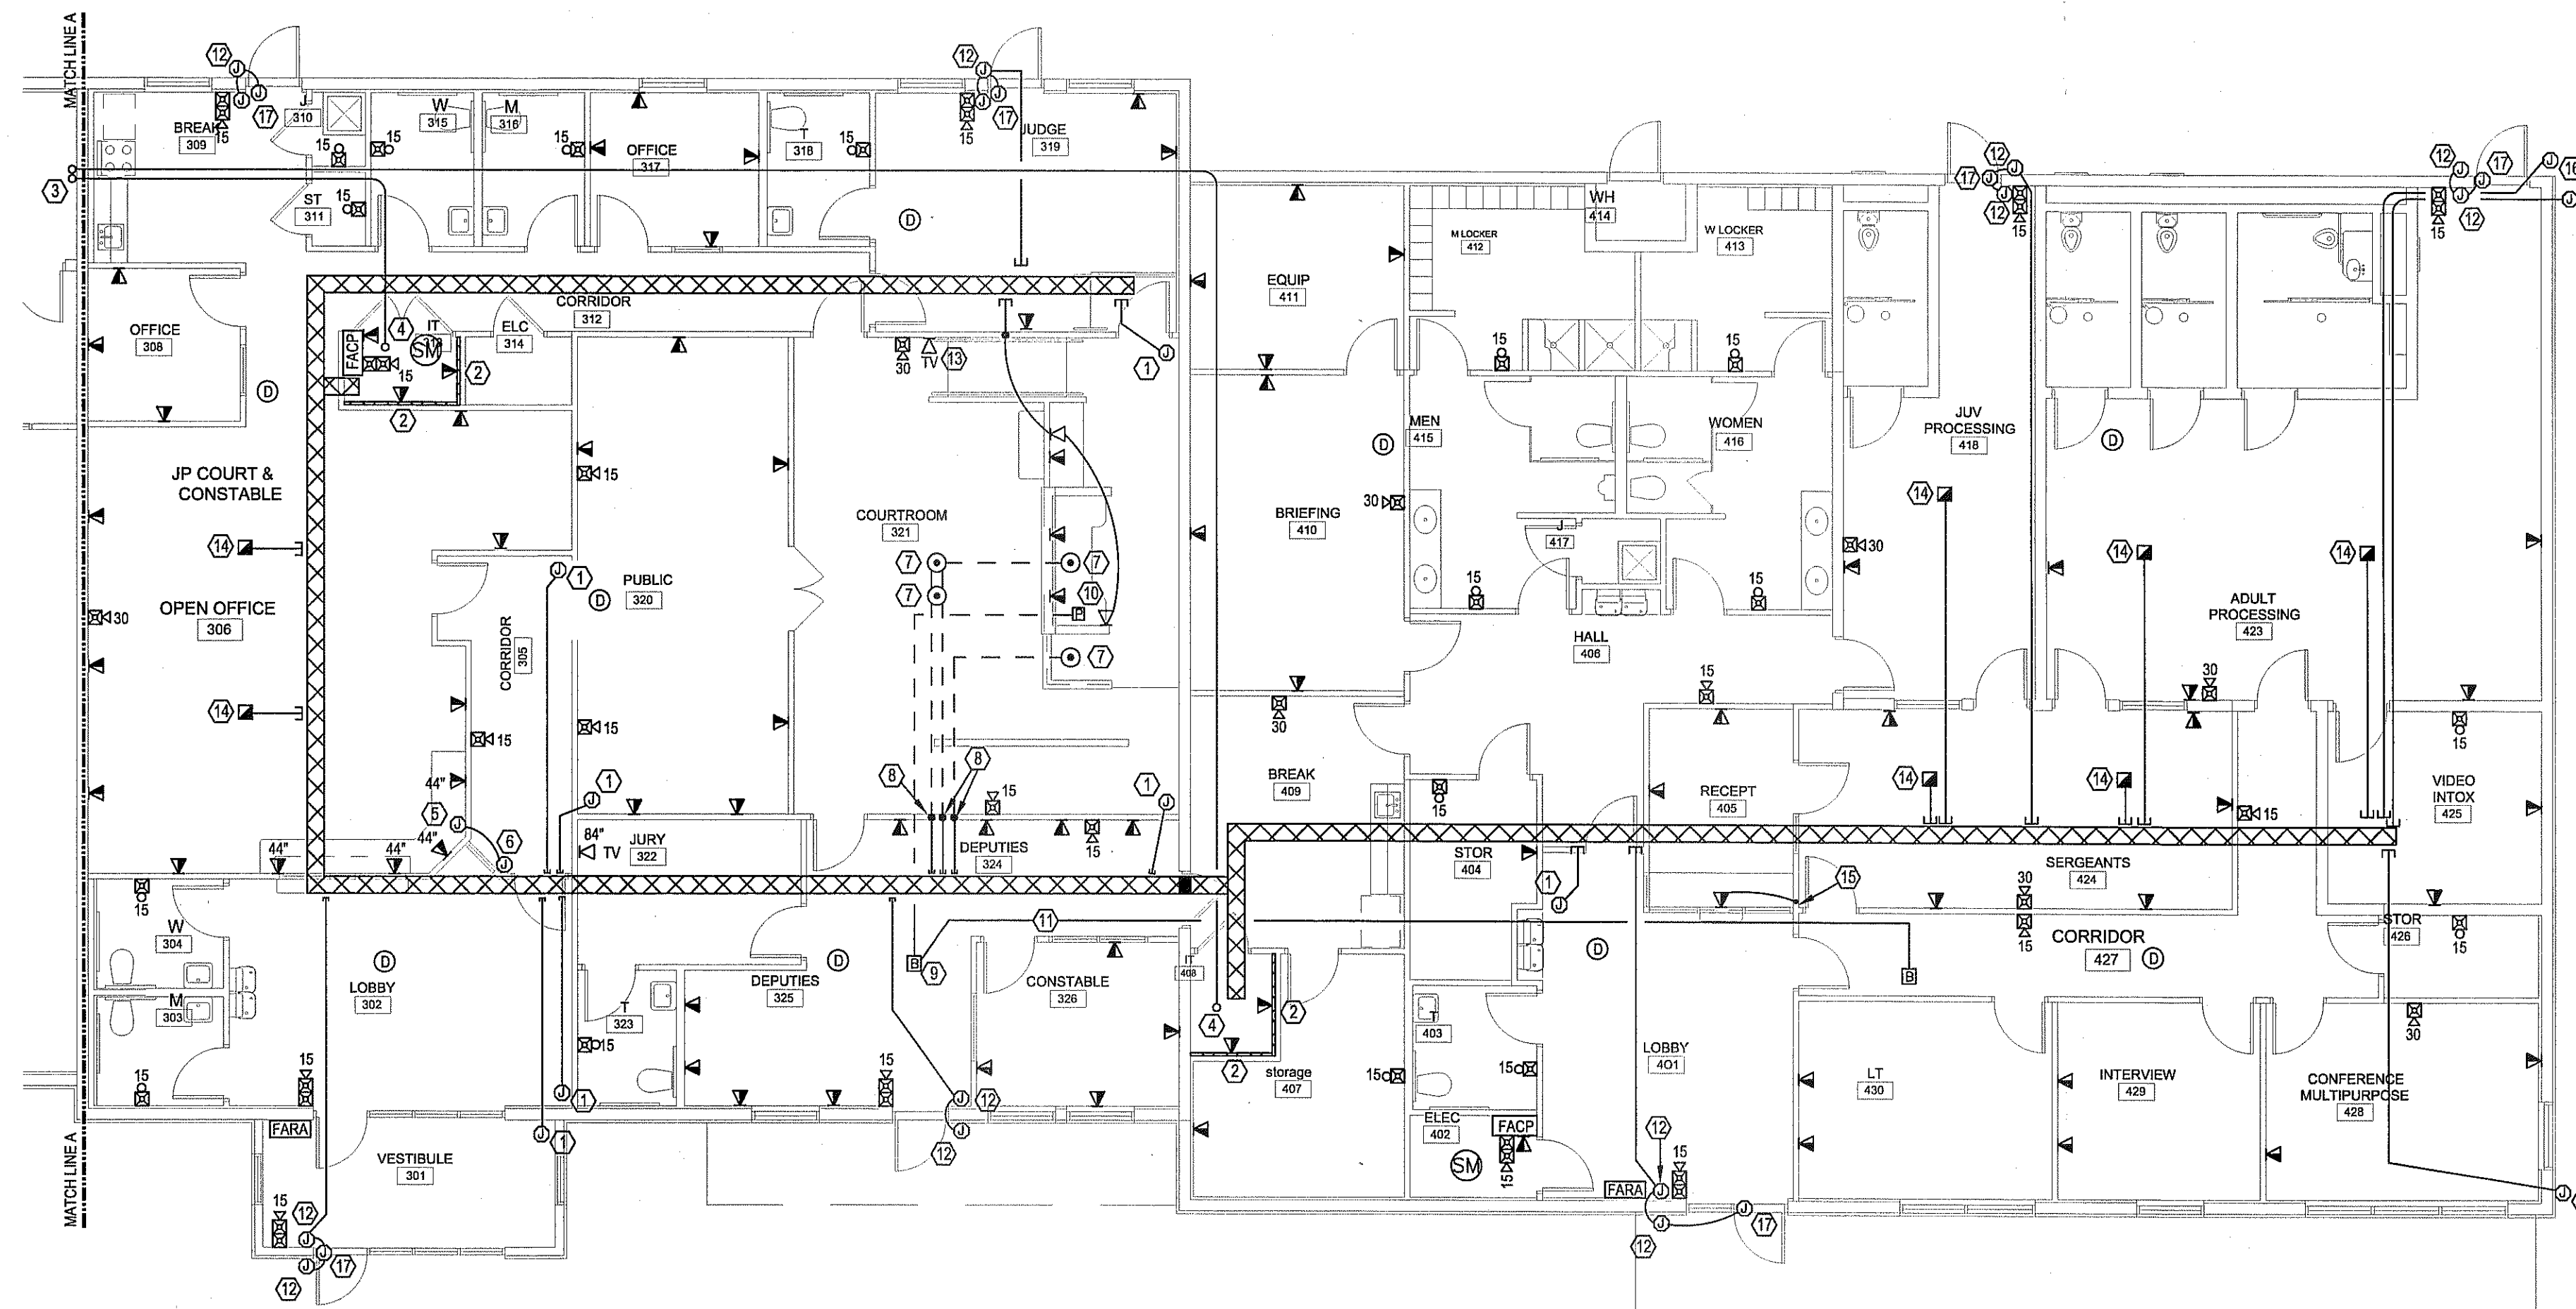

PARTIAL SPECIAL SYSTEMS PLAN

SCALE: 1/8" = 1'-0"

JUSTICE OF PEACE & SHERIFF

SPECIAL SYSTEMS KEYED NOTES

- ① INSTALL J-BOX AT 96" AFF CEILING FOR CAMERA, INSTALL 3/4" CONDUIT WITH PULLSTRING TO CABLE TRAY, COORDINATE EXACT LOCATION WITH OWNER BEFORE DOING ANY WORK.
- ② INSTALL 3/8" FIRE TREATED PLYWOOD, COMPLETELY ON TWO WALL OF IT ROOM.
- ③ INSTALL (2) 4" CONDUIT WITH (4) PULLSTRING ON EACH CONDUIT, USE LONG 36" LONG SWEEPS RADIUS ELLS ON ALL TURNS.
- ④ INSTALL (1) 4" CONDUIT WITH (4) PULLSTRING ON EACH CONDUIT, USE LONG 36" LONG SWEEPS RADIUS ELLS ON ALL TURNS.
- ⑤ INSTALL J-BOX AT 48" AFF FOR PUSH BUTTON DOOR LOCK, COORDINATE EXACT LOCATION. INSTALL 1" CONDUIT WITH PULLSTRING TO ELECTRONIC MAGNETIC DOOR LOCK.
- ⑥ INSTALL J-BOX ABOVE CEILING FOR MAGNETIC DOOR LOCK, INSTALL 1" CONDUIT WITH PULLSTRING TO PUSH BUTTON J-BOX.
- ⑦ INSTALL FLOOR MOUNTED BOX WITH POWER RECEPTACLE, PHONE/DATA RECEPTACLE AND MICROPHONE JACK. COORDINATE WITH OWNER FOR EXACT LOCATION.
- ⑧ STUBB UP 1" CONDUIT WITH PULLSTRING THRU WALL TO NEAREST CABLE TRAY.
- ⑨ INSTALL 4" SQ. DEEP J-BOX AT CEILING FOR BUZZER.
- ⑩ INSTALL 4" SQ. DEEP J-BOX BELOW COUNTER FOR PANIC BUTTON. INSTALL 1" CONDUIT WITH PULLSTRING TO J-BOX FOR BUZZER.
- ⑪ 1" CONDUIT WITH LOW VOLTAGE WIRING TO SHERIFF OFFICE BUZZER.
- ⑫ INSTALL WEATHER PROOF 4" SQ. DEEP J-BOX FOR KEYCARD LOCK OPENER, COORDINATE WITH OWNER BEFORE DOING ANY WORK. INSTALL 1" CONDUIT TO NEAREST CABLE TRAY.
- ⑬ INSTALL TV CONNECTION IN GYP. BOARD SOFFIT FOR TELEVISION, COORDINATE WITH OWNER FOR EXACT LOCATION BEFORE DOING ANY WORK.
- ⑭ INSTALL CEILING MOUNTED 4" SQ. DEEP J-BOX FOR FUTURE POWER POLE, INSTALL 1" CONDUIT WITH PULLSTRING TO NEAREST CABLE TRAY. COORDINATE WITH OWNER FOR EXACT LOCATION.
- ⑮ STUBB-UP 3/4" CONDUIT WITH PULLSTRING TO ABOVE SUSPENDED CEILING.
- ⑯ INSTALL WEATHER PROOF 4" SQUARE J-BOX WITH WEATHER PROOF COVER AT 12" ABOVE FINISH GRADE FOR CAMERA, INSTALL 3/4" CONDUIT WITH PULLSTRING TO NEAREST CABLE TRAY. COORDINATE WITH OWNER FOR EXACT LOCATION. WATER PROOF AND FIRE PROOF ALL PENETRATIONS INTO BUILDING.
- ⑰ INSTALL 4" SQ. J-BOX ABOVE DOOR FOR CONTROLS.

LEGEND

 12" WIRE MESH CABLE TRAY

REVISIONS



DRAWN BY: STAFF
CHECKED BY: STAFF
DATE: DEC. 2012
PROJ. NO.: 9.0307

PARTIAL SPECIAL
SYSTEMS PLAN